



CONSTRUCTION DETAILS

PROJECT INFO

PROJECT ADDRESS: Op. Cemil Topuzlu Caddesi
No:108
Kadiköy/ İstanbul

DESIGNER: Zeynep İnanc

BUILDER: Emre Burteçene

Client: Cenk Demir

LAND AREA: 3280.30 m²

FLOOR AREA: Roof - 1546.95 m²
Ground Floor - 1444.29 m²
Underground Floor - 1608.80 m²
Total - 3300.04 m²

SYMBOLS

	Elevation Number		Floor Finish	US- Underground Floor Space
	Section Number		Roof Finish	GS- Ground Floor Space
	Detail Number		Wall Finish	Sym- Symbol
	Sheet Drawn On		Door type	
	Sheet Drawn On		Window type	

VICINITY MAP



PLOT OF SURVEY

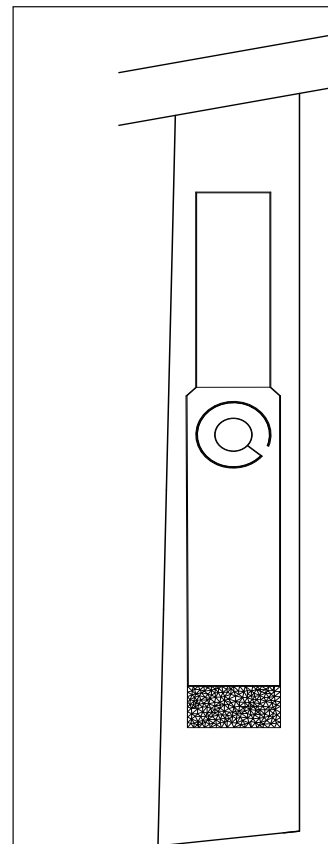


TABLE OF CONTENTS

Page	
1	Cover Sheet
2	Site Plan
3	Underground Floor; Foundation and Floor Plan
4	Ground Floor; Foundation and Floor Plan
5	Roof Plan
6	Elevations
7	Sections
8	Green Roof Construction Details
9	Build-Up Desk Details
10	Canopy Holding System Details
11	Canopy Construction Details
12	Ramp Construction Details
13	Slope Construction Details
14	Lighting Schedule
15	Finishes
16	Finish Schedule


COVER SHEET

Project Name and Address
ZEYNEP INANC
UAL-LCC

Project Name and Address
Final Major Project
OP. CEMİL TOPUZLU
CADDESI NO:108
KADIKÖY / İSTANBUL


Project
FMP
Date
28/04/2018
Scale

1 of 16

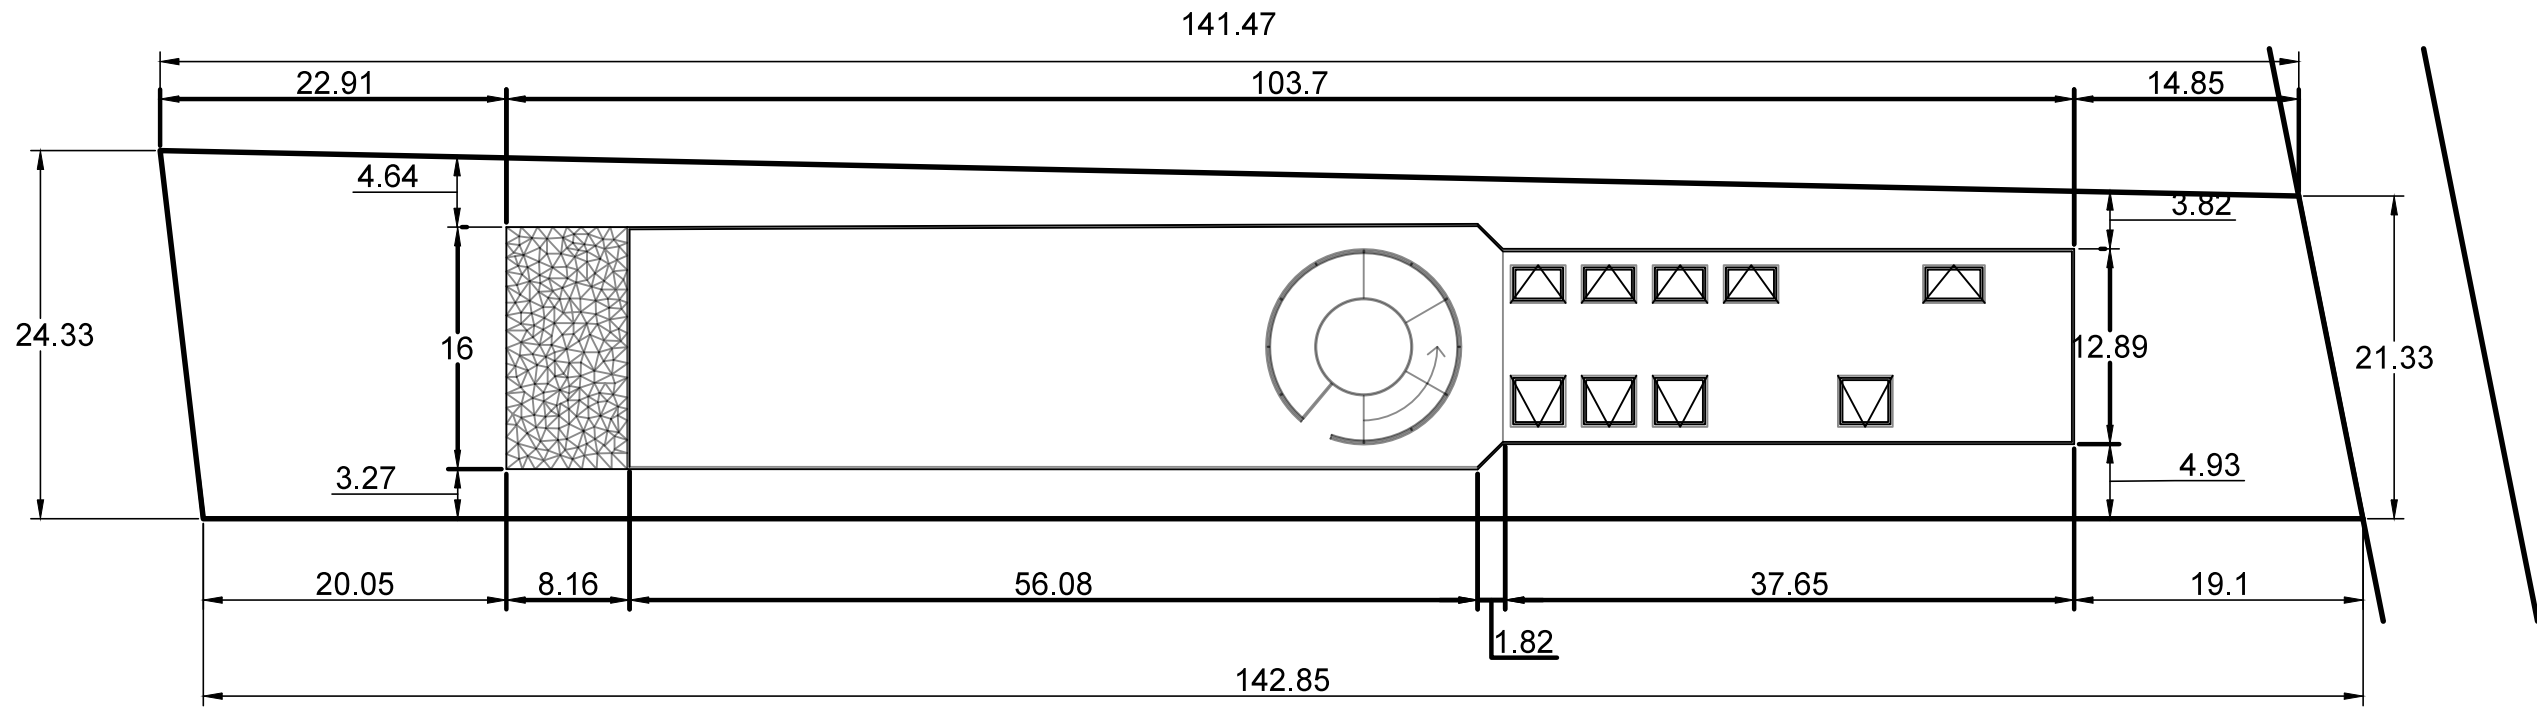


FOUNDATION PLAN ON SITE

SCALE: 1:500

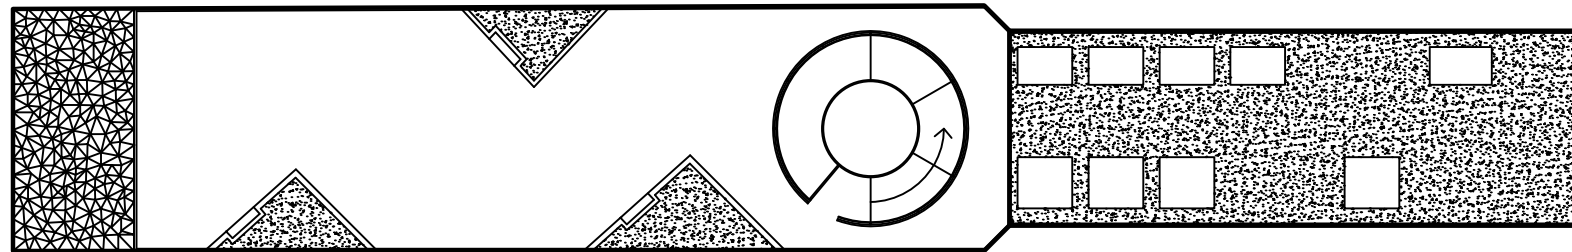


ROOF PLAN

SCALE: 1:500

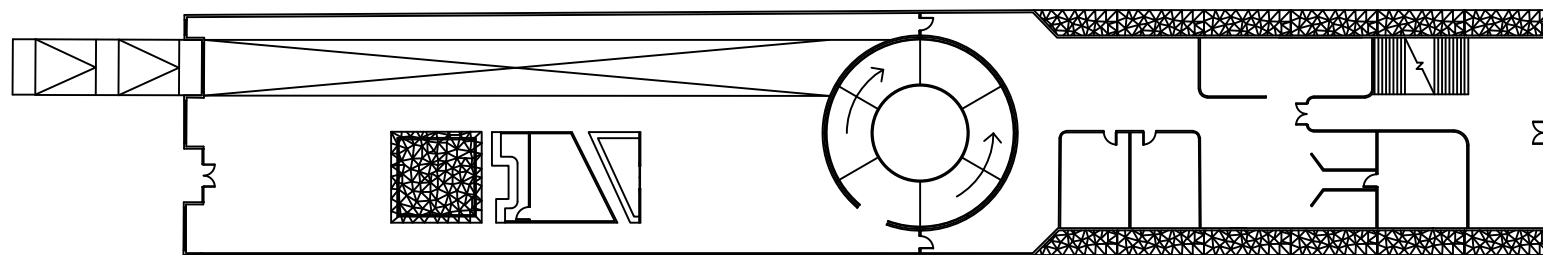

GROUND FLOOR PLAN

SCALE: 1:500

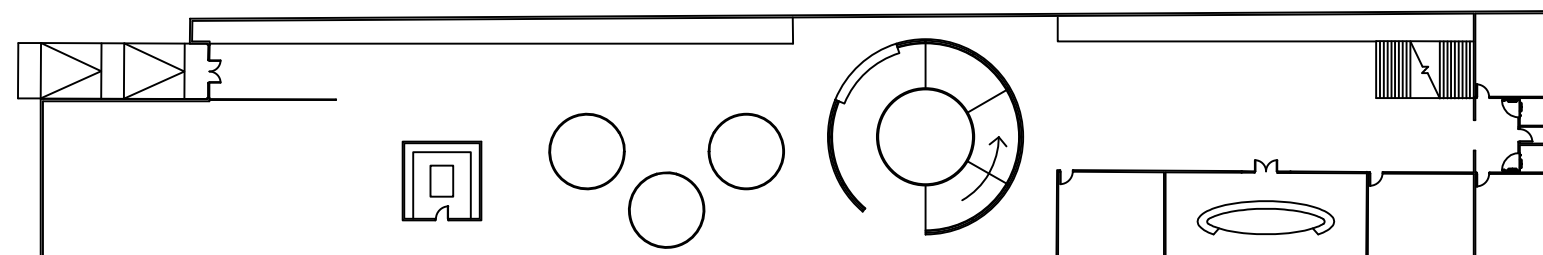

UNDERGROUND FLOOR PLAN


SCALE: 1:500

SITE PLAN

NOTES:
1- Dimentions for site and foundation are shown on the left.

2- Image shows that where foundation is located on the site.

3- Floor plans with interior and exterior walls are shown on the second box.

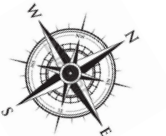


Client Name and Address
ZEYNEP INANC
UAL-LCC



Project Name and Address
Final Major Project
OP. CEMİL TOPUZLU
CADESİ NO:108
KADIKÖY / ISTANBUL


Project
FMP
Date
28/04/2018
Scale
1:500

2 of 16

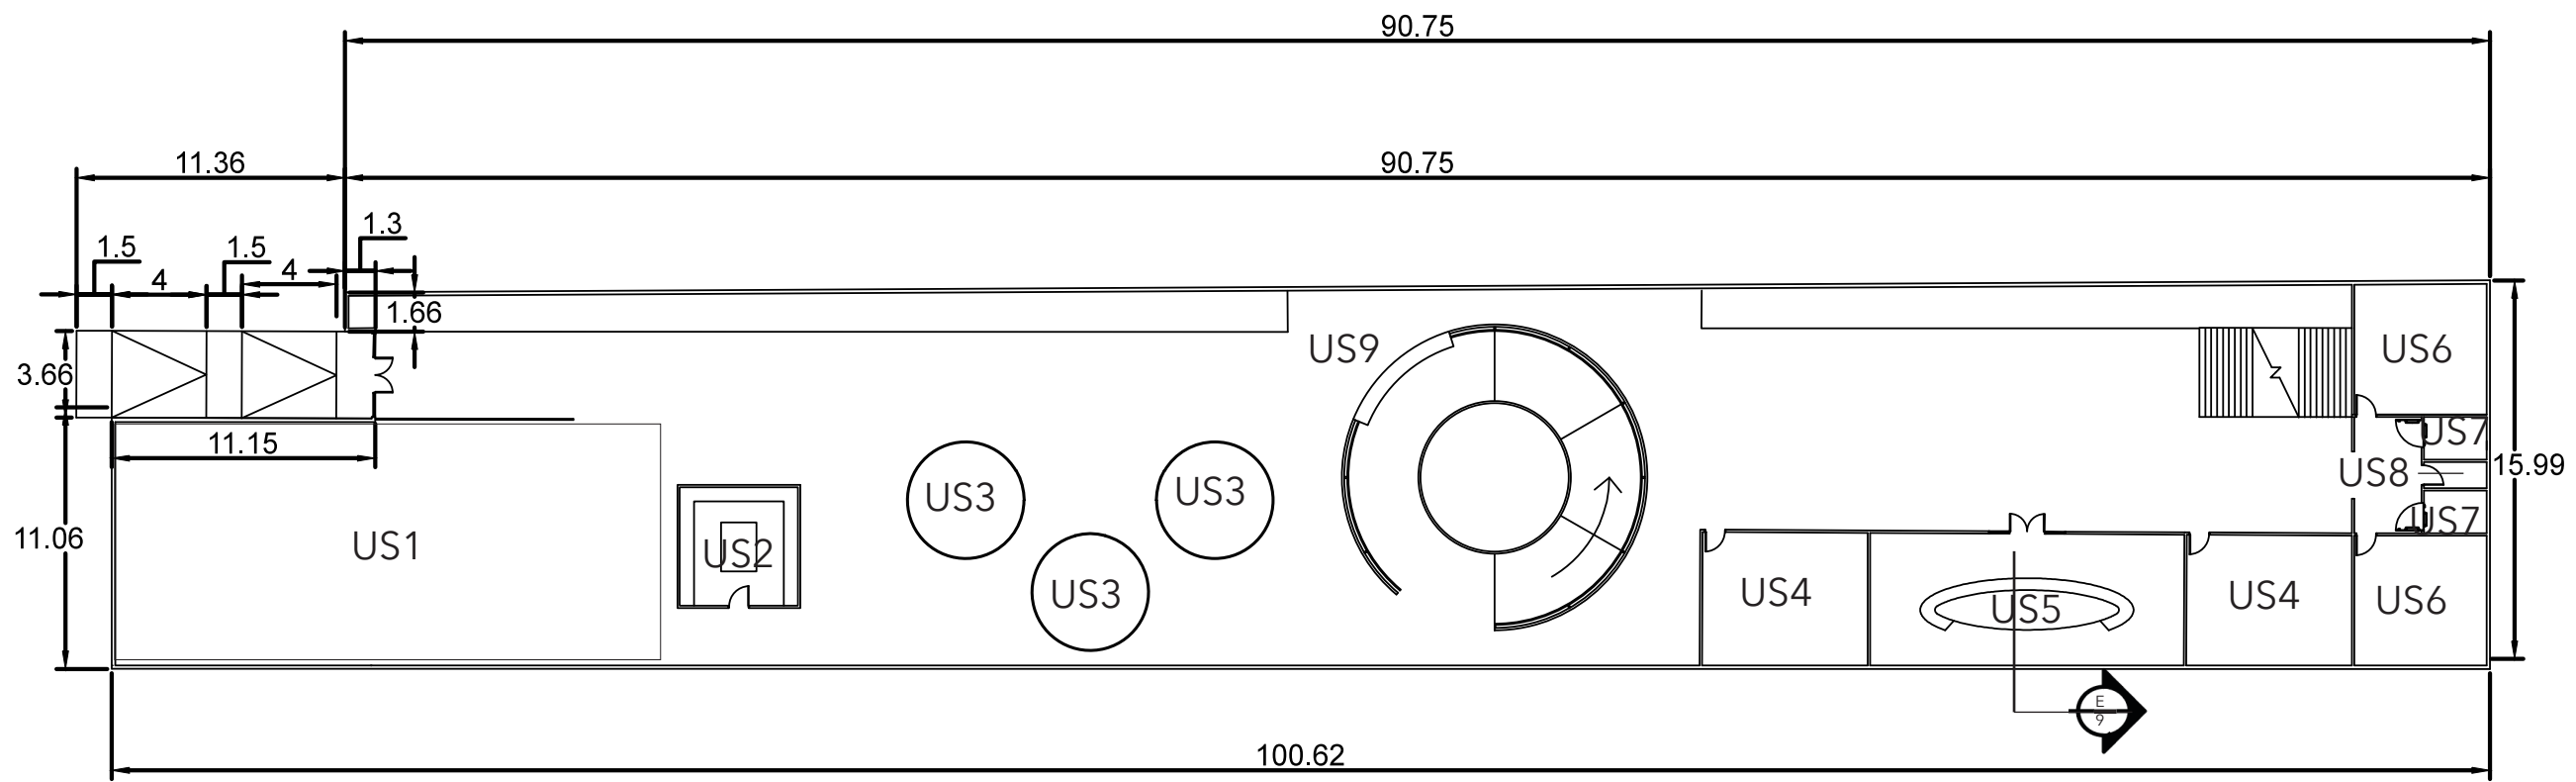

FOUNDATION PLAN OF UNDERGROUND

SCALE: 1:300

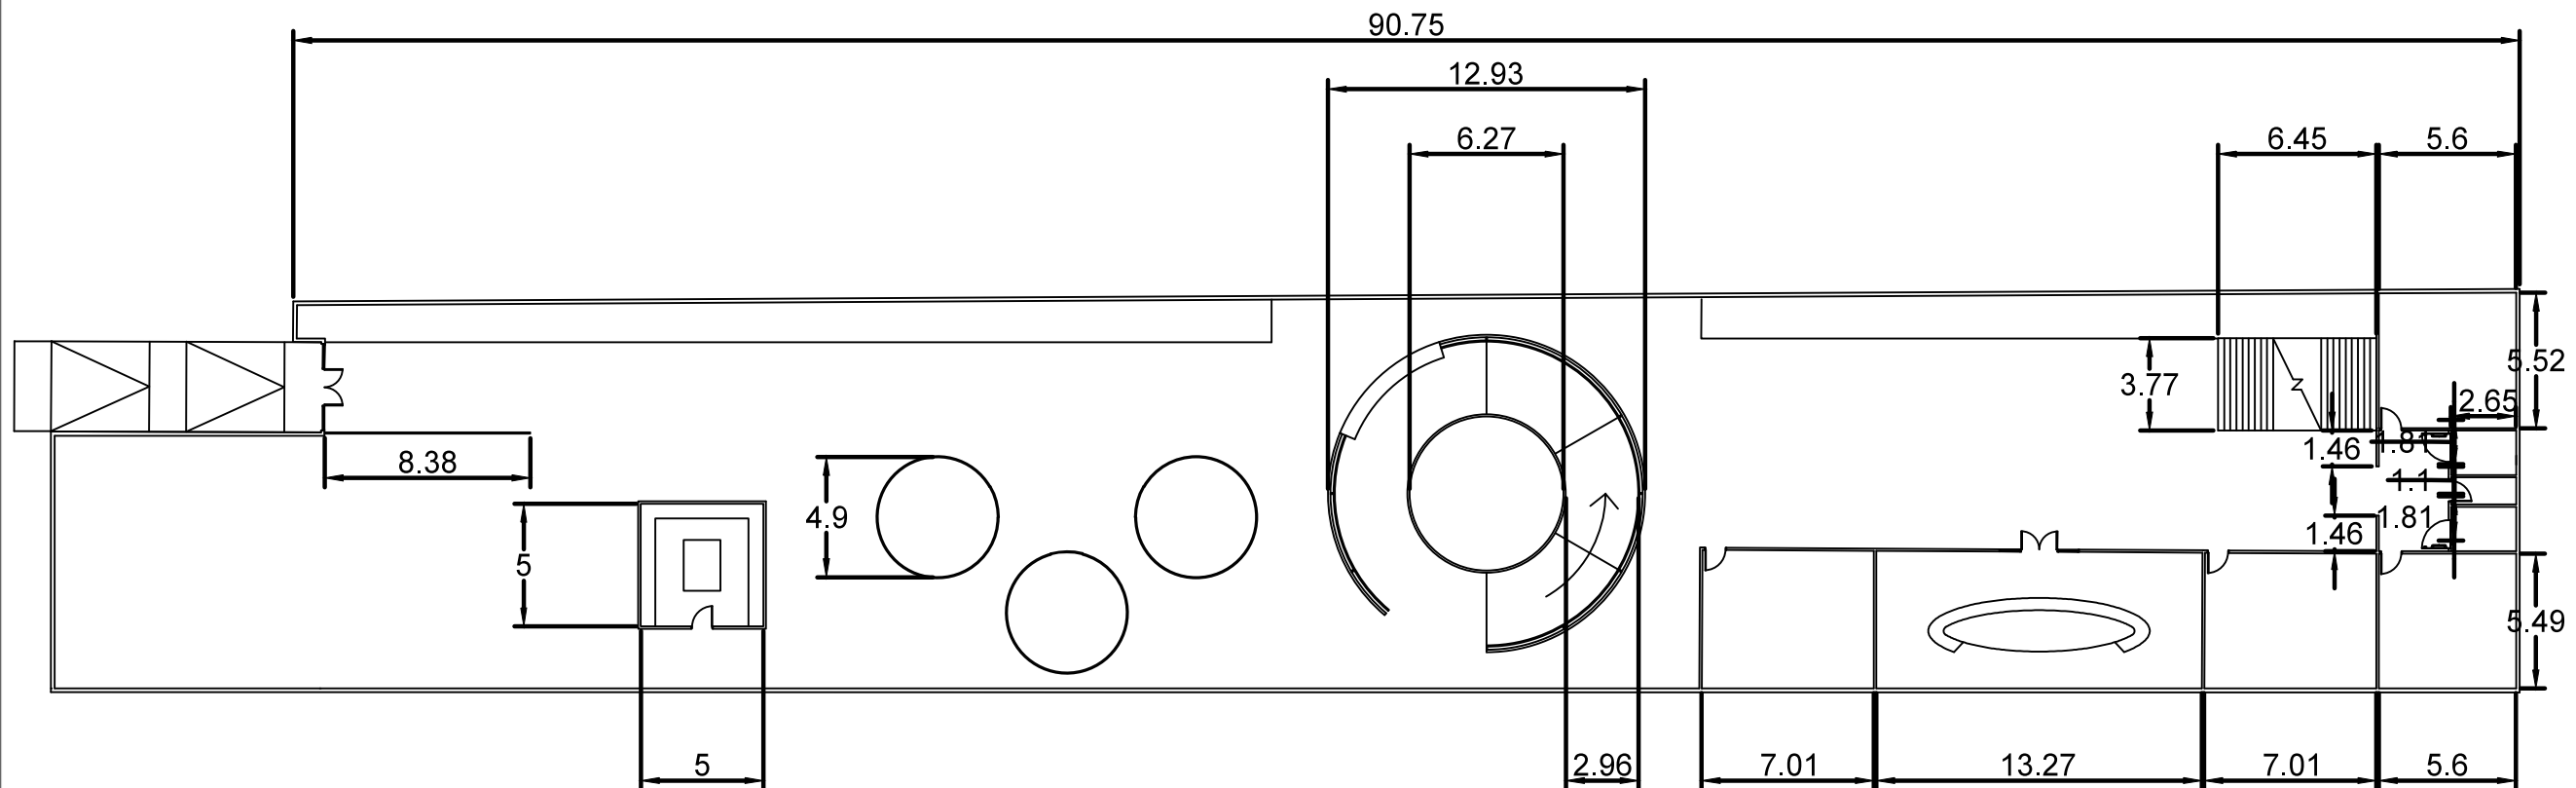

UNDERGROUND FLOOR PLAN

SCALE: 1:300

UNDERGROUND
FLOOR PLAN

US1 - Exhibition
Room

US2 - Biomimicry
Research Room

US3 - Training
Rooms

US4 - Workshops

US5 -
Conversation
Room

US6 - Toilets

US7 - Disabled
Toilets

US8 - Utility

US9 - Information




Client Name and Address
ZEYNEP INANC
UAL-LCC

Project Name and Address
Final Major Project
OP. CEMİL TOPUZLU
CADESİ NO:108
KADIKÖY / İSTANBUL


Project
FMP
Date
28/04/2018
Scale

3 of 16

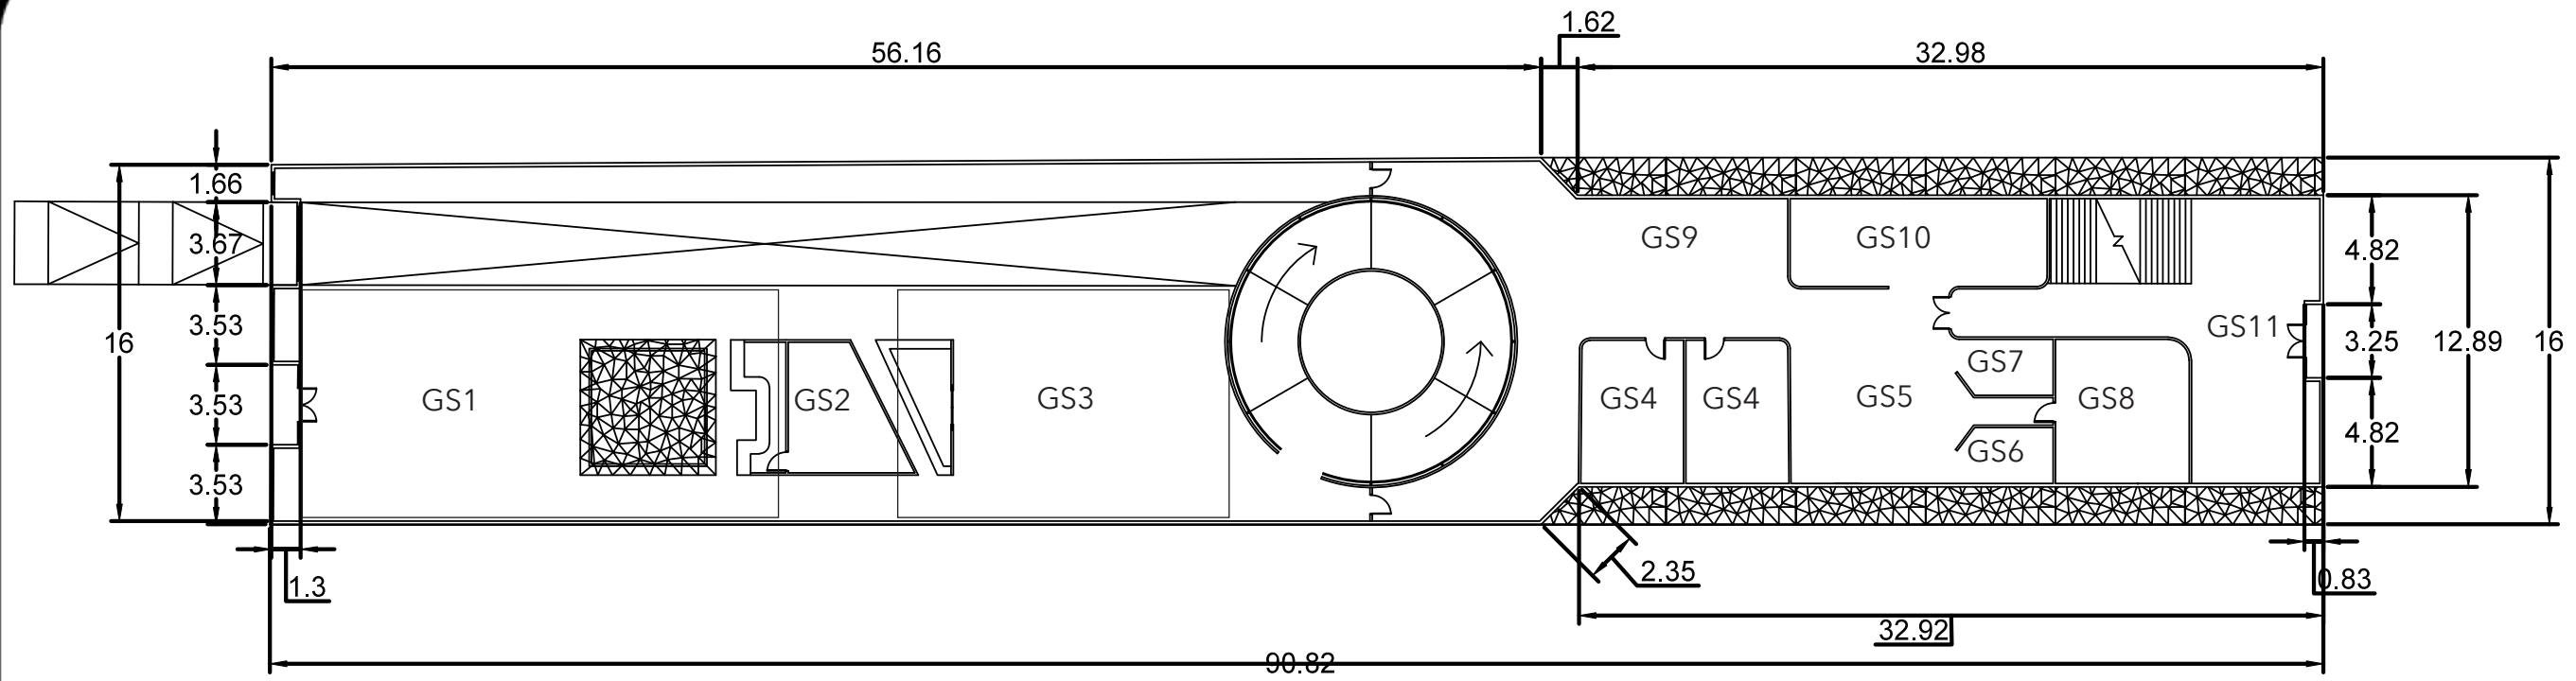

FOUNDATION PLAN ON SITE

SCALE: 1:300

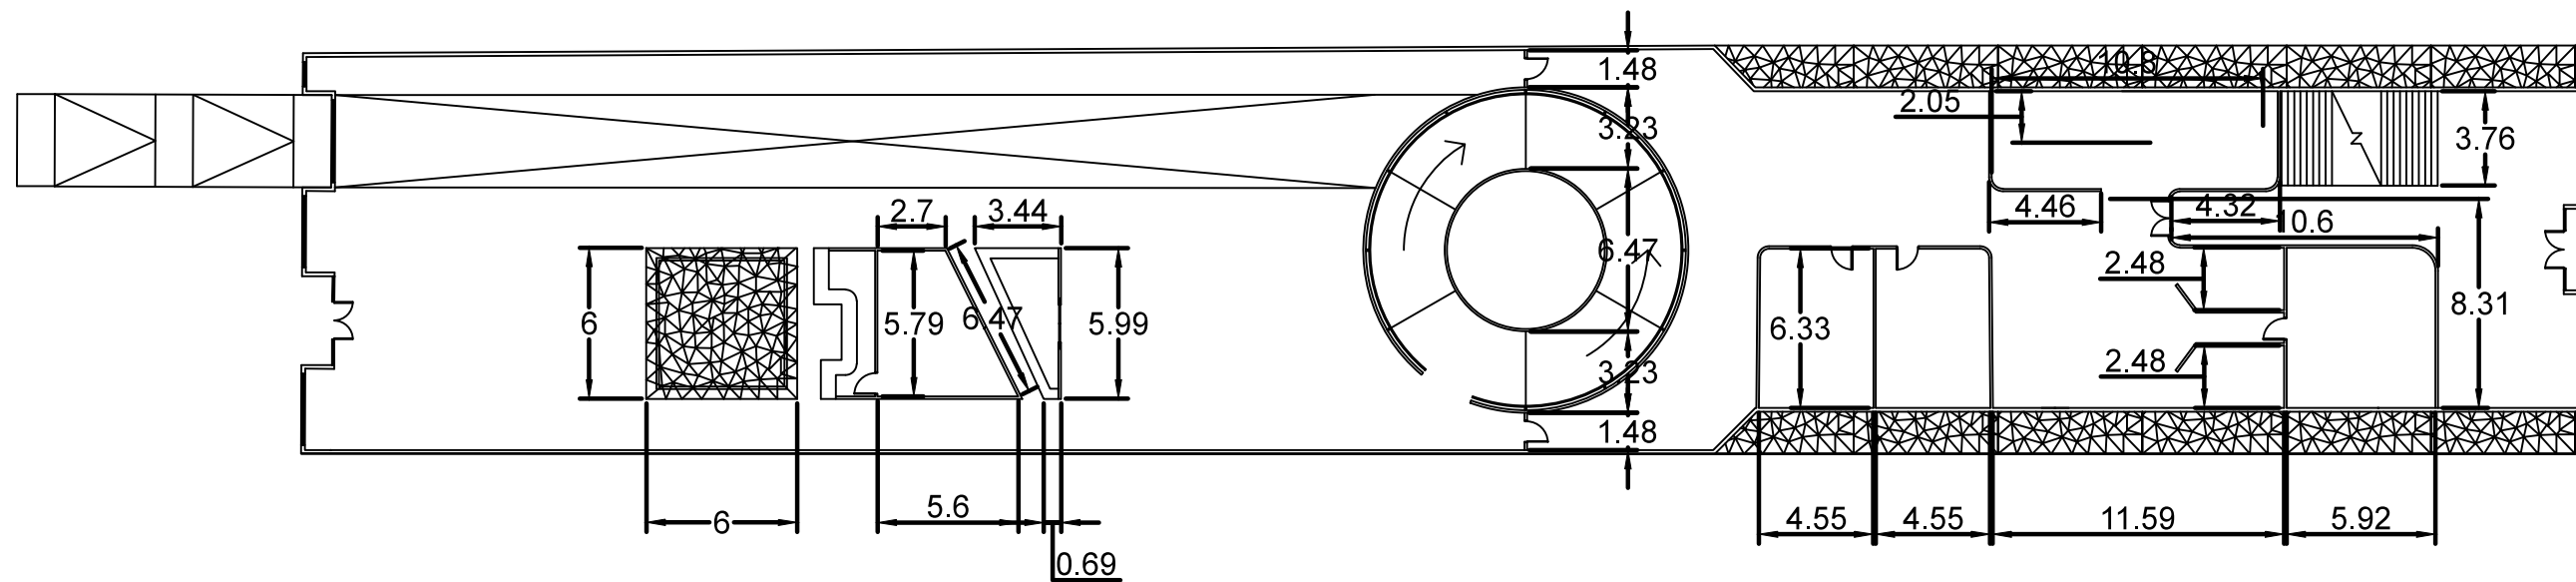


GROUND FLOOR PLAN

SCALE: 1:300

GROUND FLOOR PLAN

- GS1 - Cafe
- GS2 - Kitchen
- GS3 - Library
- GS4 - Offices
- GS5 - Work Stations
- GS6 - Printing and Storage
- GS7 - Kitchenette
- GS8 - Meeting Room
- GS9- Break-out Space
- GS10 - Collective WorkSpace
- GS11- Reception

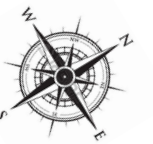


Client Name and Address
ZEYNEP INANC
UAL-LCC

Final Major Project
OP. CEMİL TOPUZLU
CADESİ NO:108
KADIKÖY / İSTANBUL


Project FMP
Date 28/04/2018
Scale 1:300

4 of 16

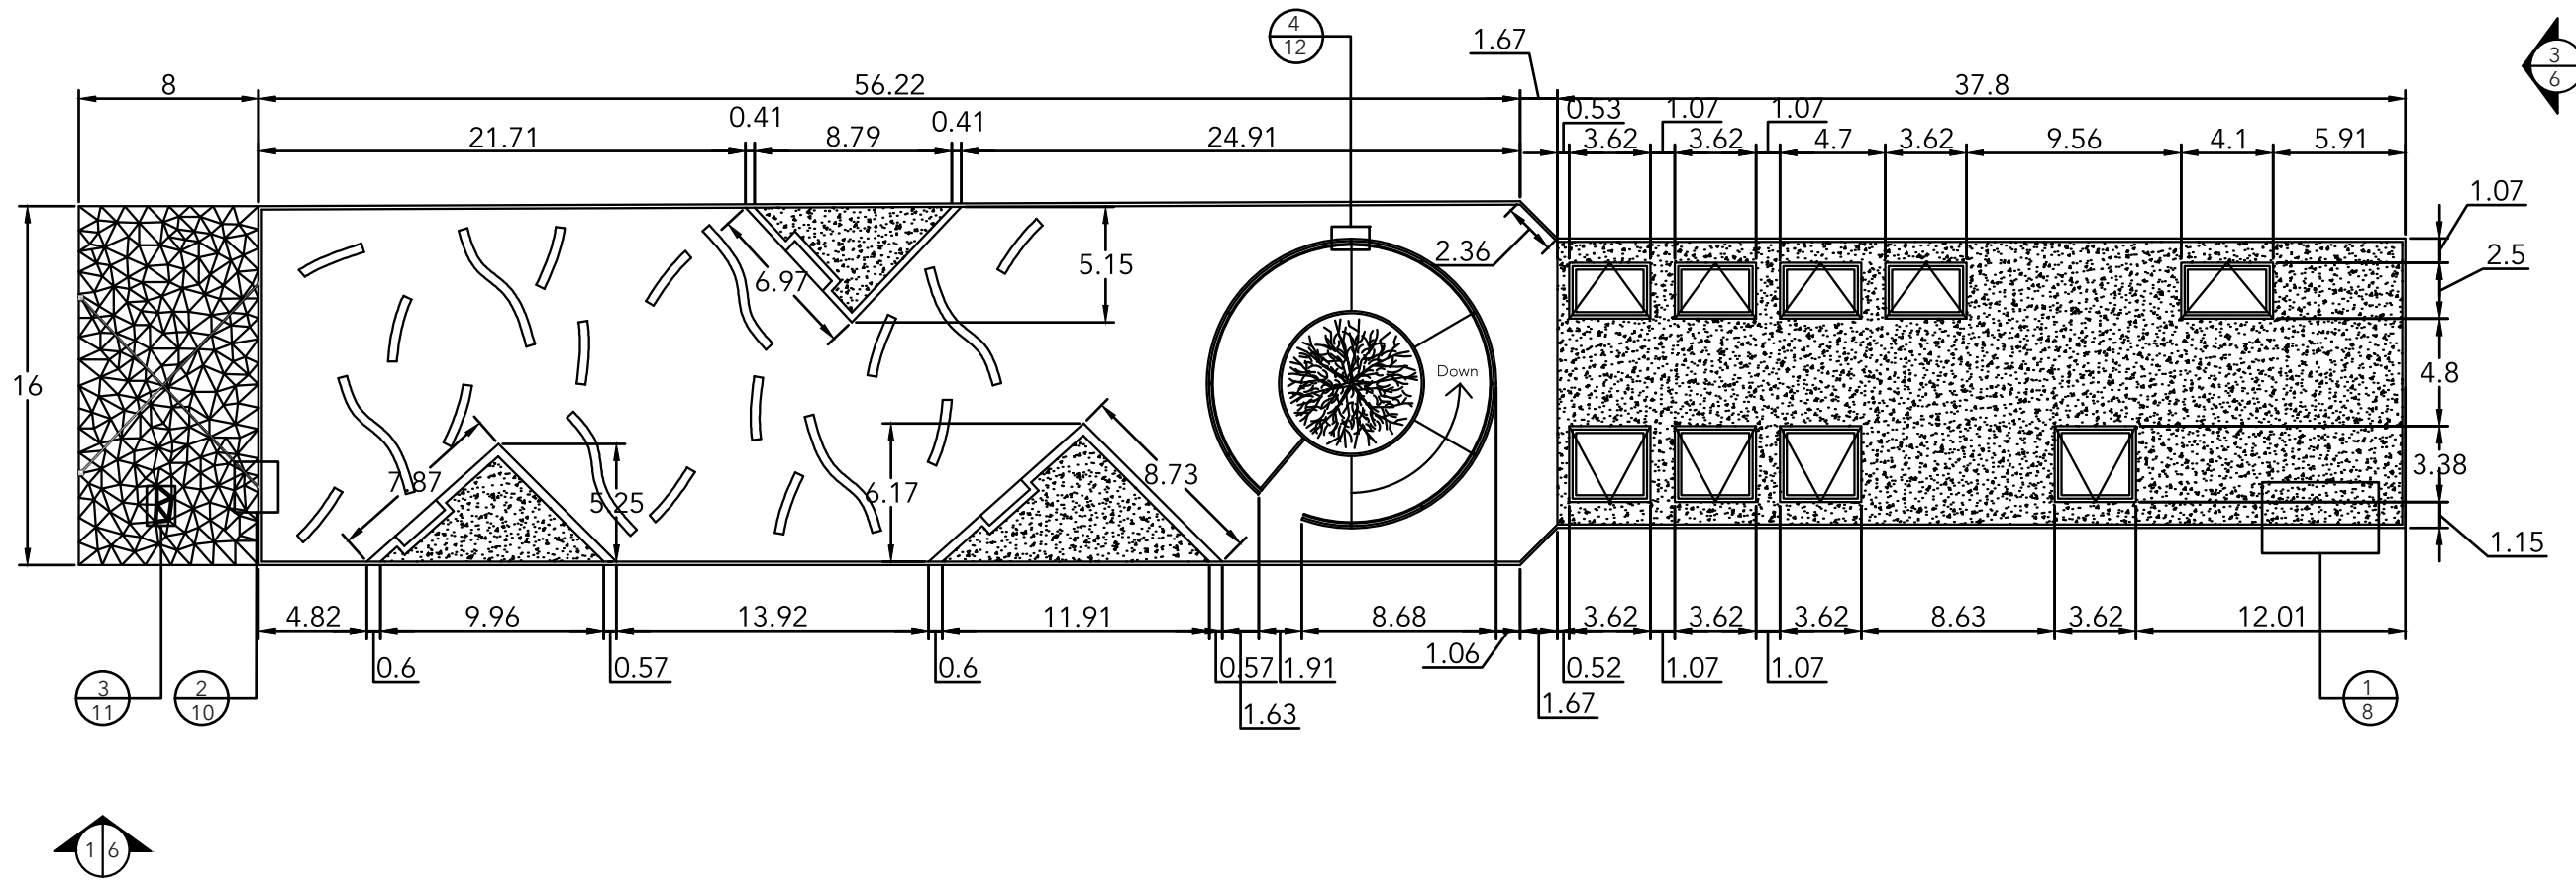

ROOF PLAN

SCALE: 1:400

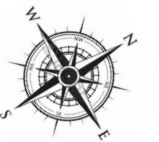


Client Name and Address
ZEYNEP INANC
 UAL-LCC



Project Name and Address
Final Major Project
 OP. CEMİL TOPUZLU
 CADDESİ NO:108
 KADIKÖY / ISTANBUL

Project
FMP
 Date
28/04/2018
 Scale

Sheet
5 of 16

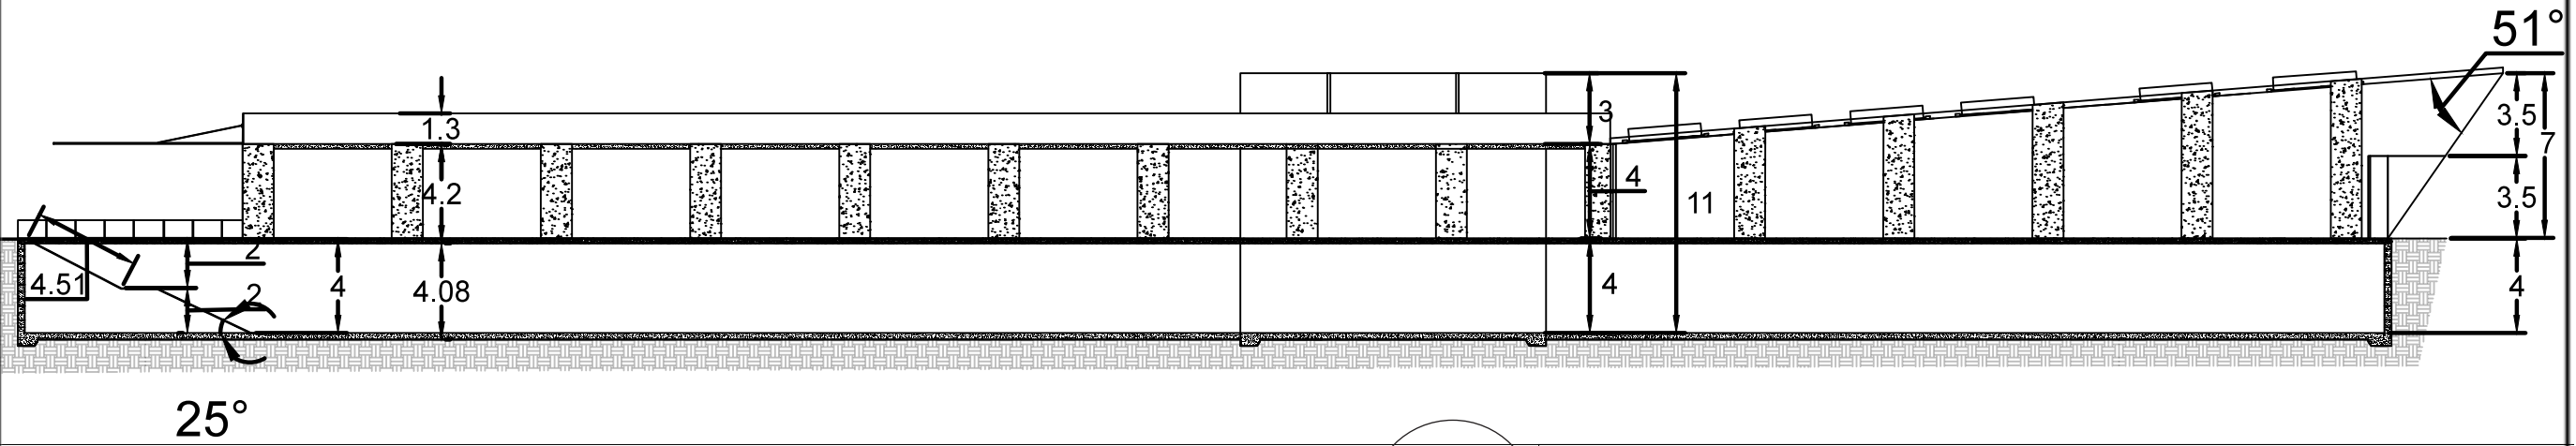


ELEVATION

1

SCALE: 1:300

6

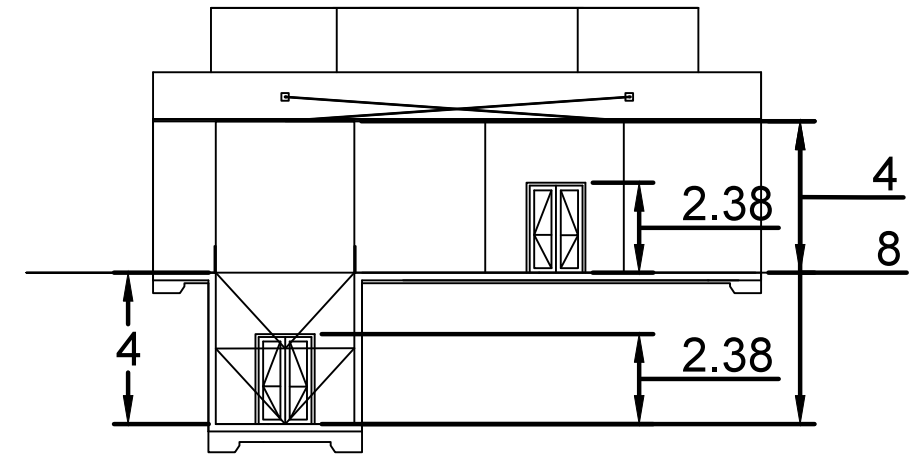


ELEVATION

2

SCALE: 1:200

6

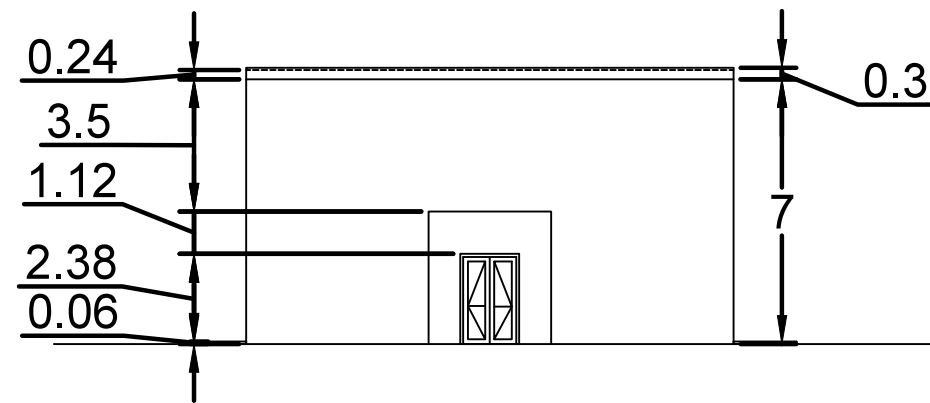


ELEVATION


3

SCALE: 1:200

6

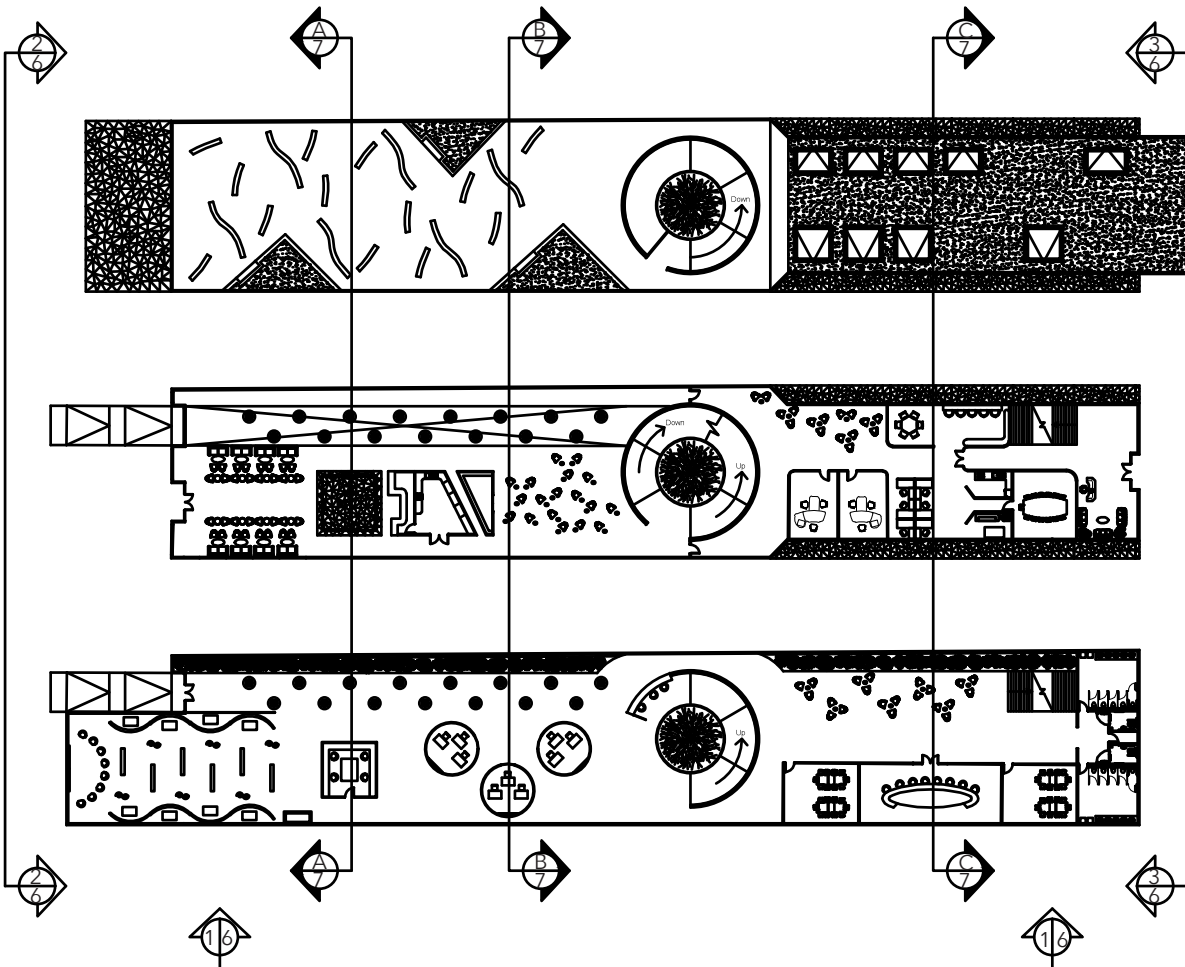


SECTIONS

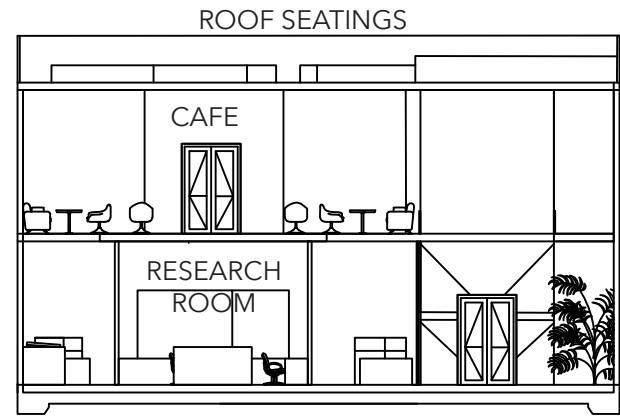


SECTION
SCALE: 1:200

A
7

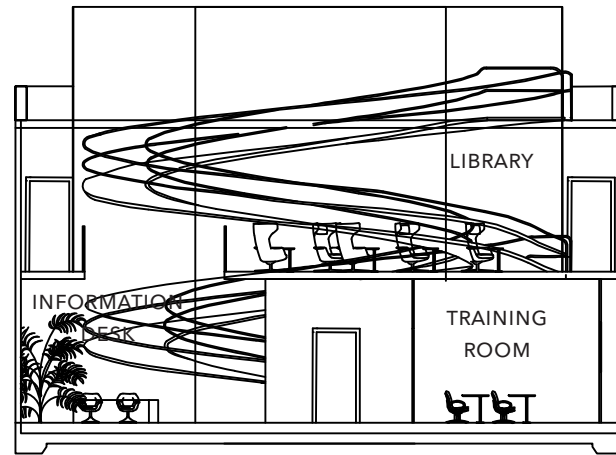


SECTION
SCALE: 1:200

B
7

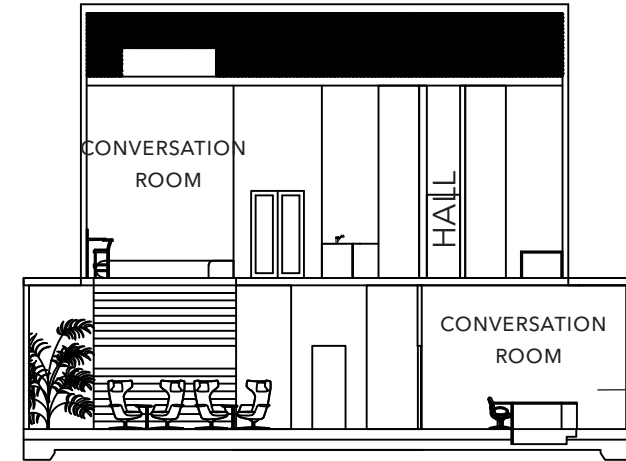

SECTION
SCALE: 1:200

C
7

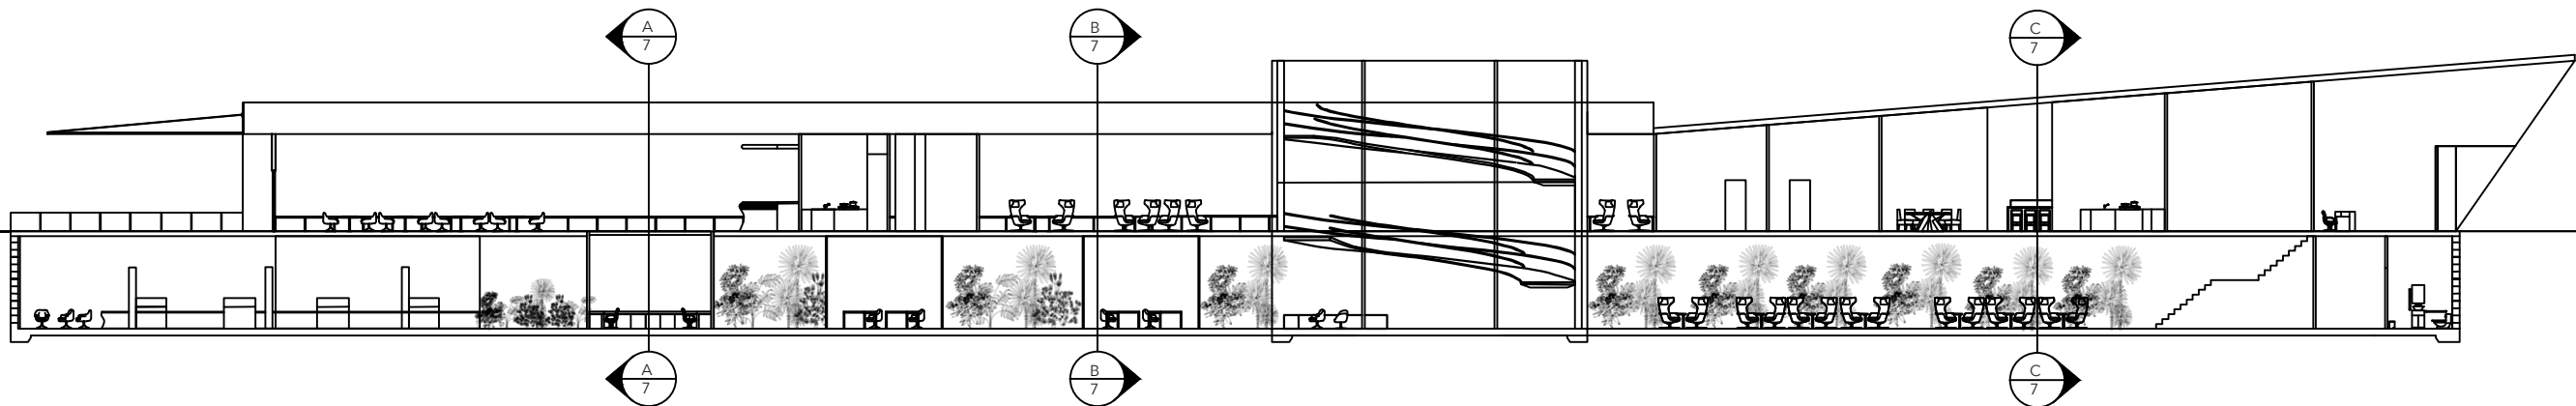

SECTION
SCALE: 1:300

D
7


Client Name and Address
ZEYNEP INANC
UAL-LCC



Project Name and Address
Final Major Project
OP. CEMİL TOPUZLU
CADESİ NO:108
KADIKÖY / ISTANBUL

Project
FMP
Date
28/04/2018
Scale

7 of 16

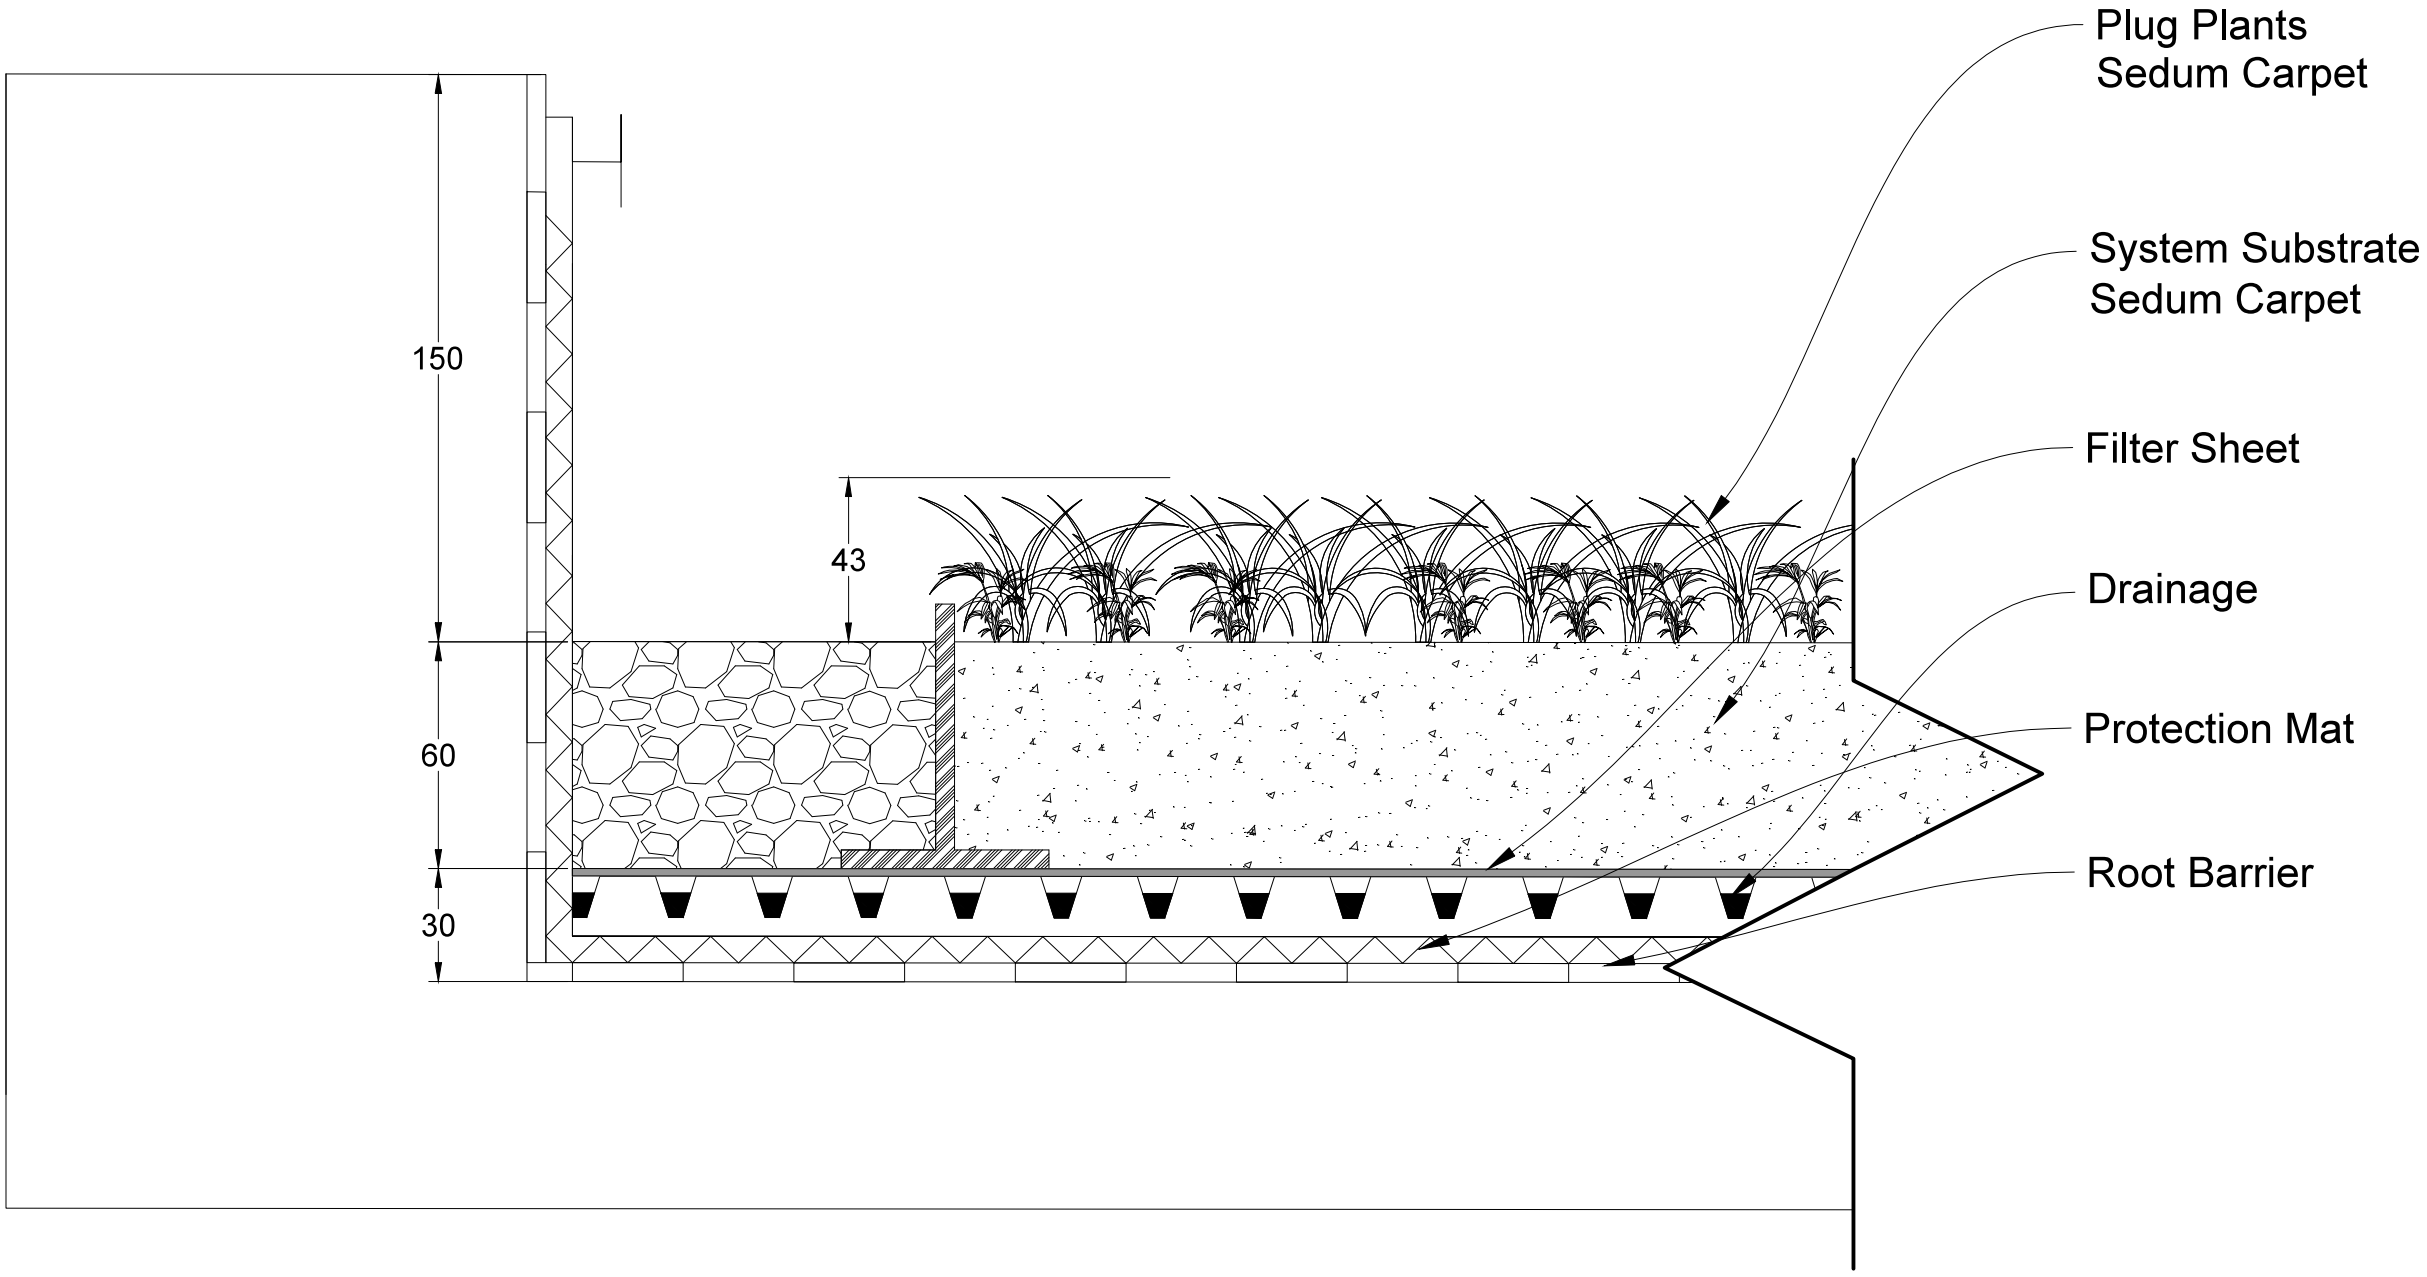


GREEN ROOF CONSTRUCTION DETAIL

SCALE: 1:2

1

GREEN ROOF
DETAIL


Client Name and Address
ZEYNEP INANC
UAL-LCC

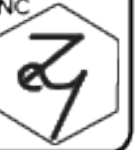

Project Name and Address
Final Major Project
OP. CEMİL TOPUZLU
CAĐDESİ NO:108
KADIKÖY / İSTANBUL

Project
FMP
Date
28/04/2018
Scale

8 of 16

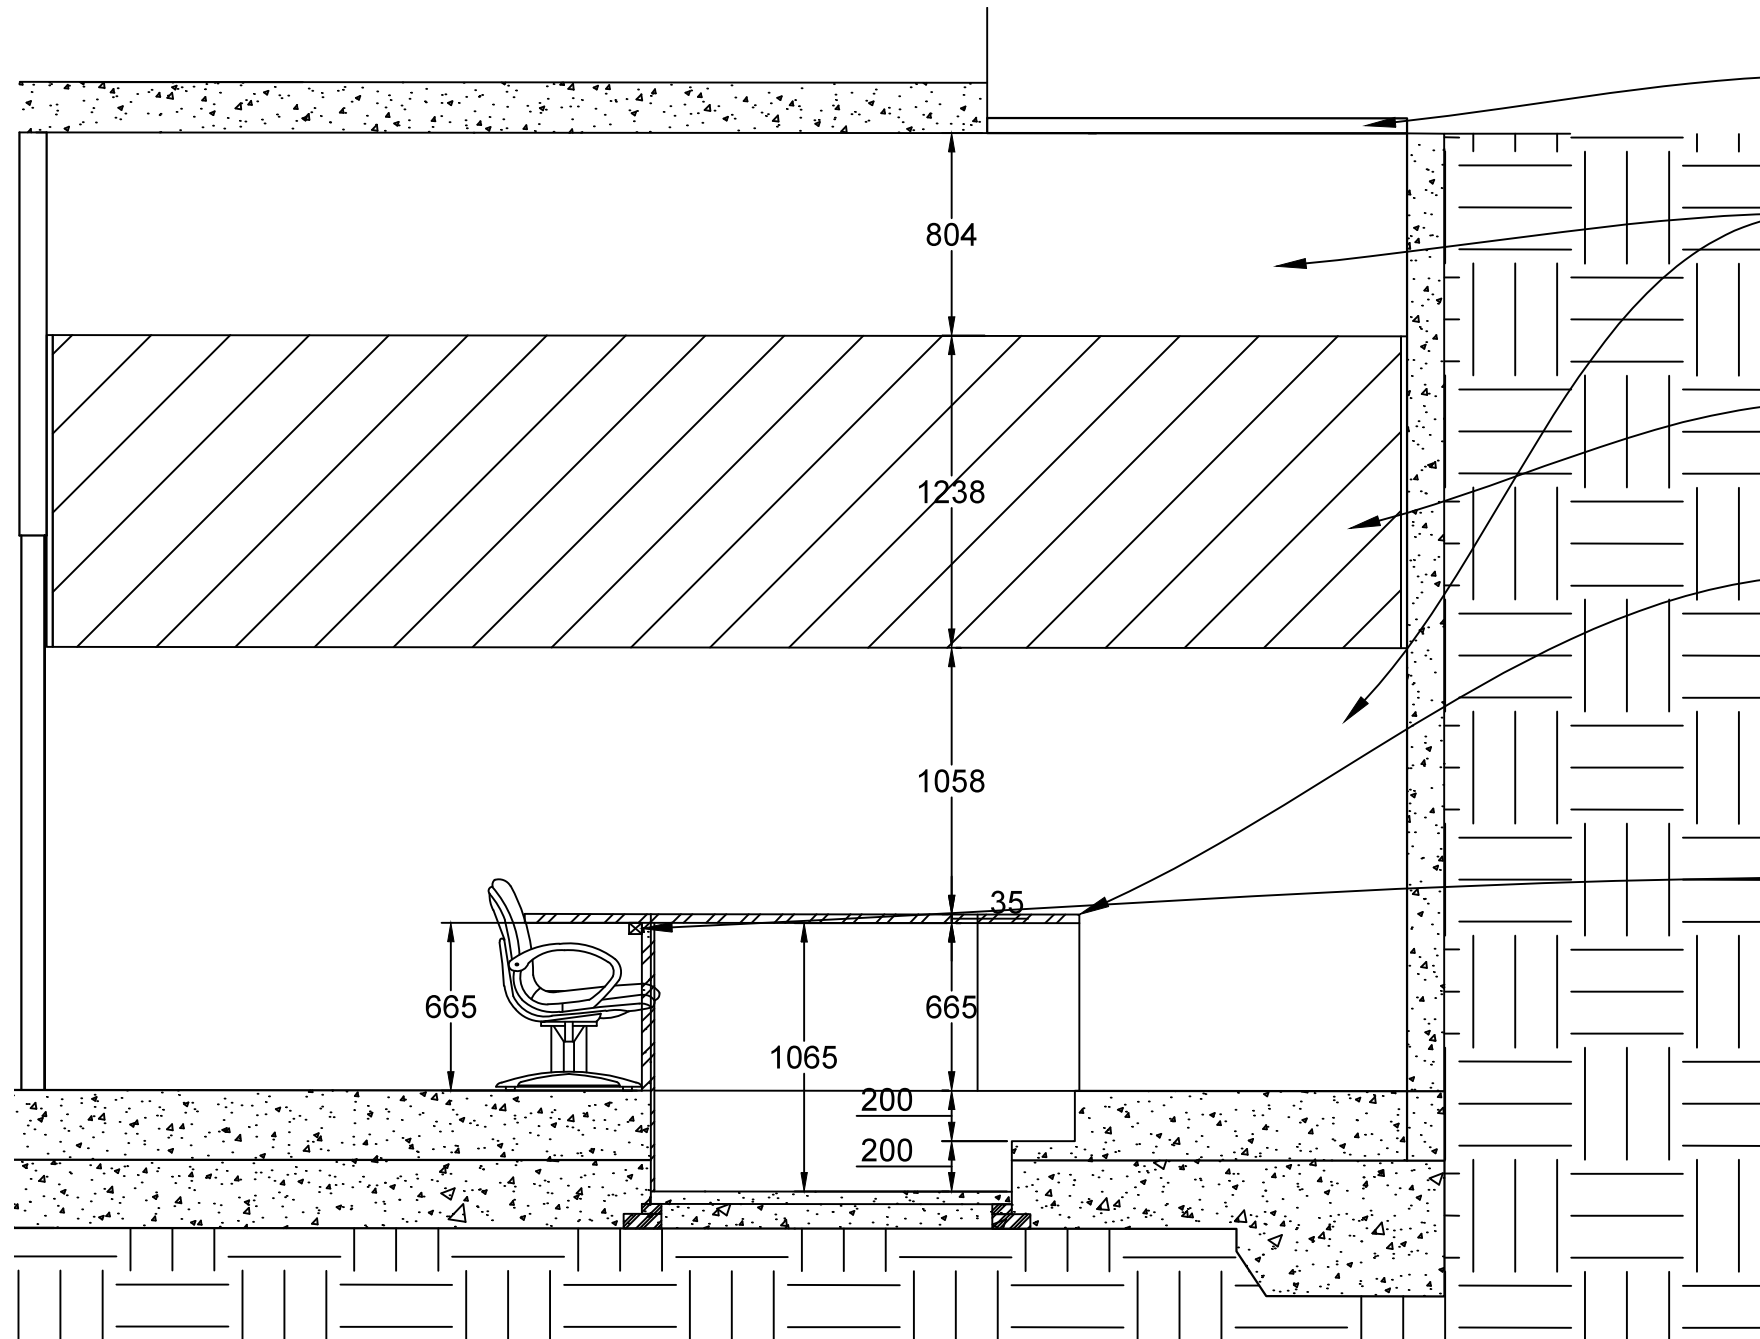

Biomimetric canopy for natural air flow
(details on sheet 11)

Valcromat Fire Reterdant
Light Grey SLG:- Thickness: 19mm
Dimensions: 3660 x 2440

BAUX Material
2030-Y40R:- Thickness: 10mm
Dimensions: 1160 x 580

Desktop- Richlite
Material
R50:- Thickness: 35mm
Dimensions: 1000 x 3000

Secure to block
desktop
MDF:-18x18 mm


CONVERSATION ROOM SECTION DETAIL

SCALE: 1:20

E
9

CONVERSATION
ROOM SECTION
DETAIL


Client Name and Address
ZEYNEP INANC
UAL-LCC

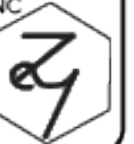


Project Name and Address
Final Major Project
OP. CEMİL TOPUZLU
CADESİ NO:108
KADIKÖY / ISTANBUL

Project
FMP
Date
28/04/2018
Scale

9 of 16

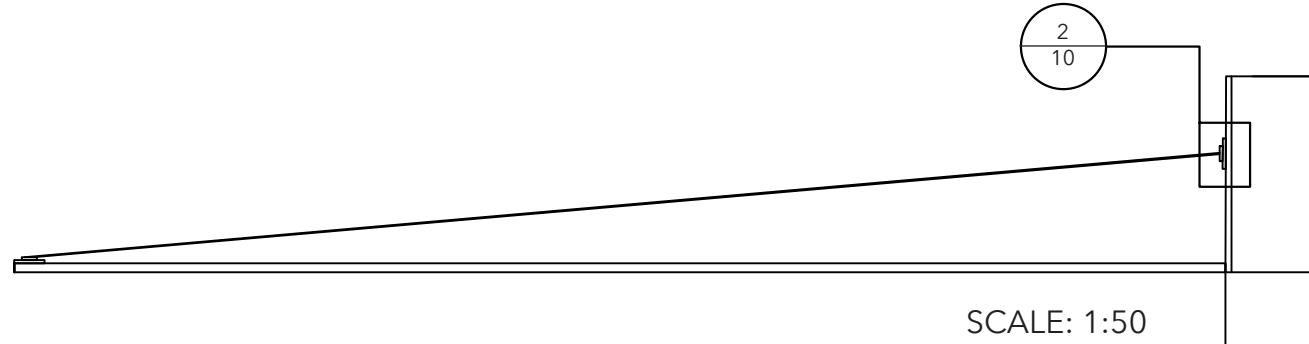

SCALE: 1:50

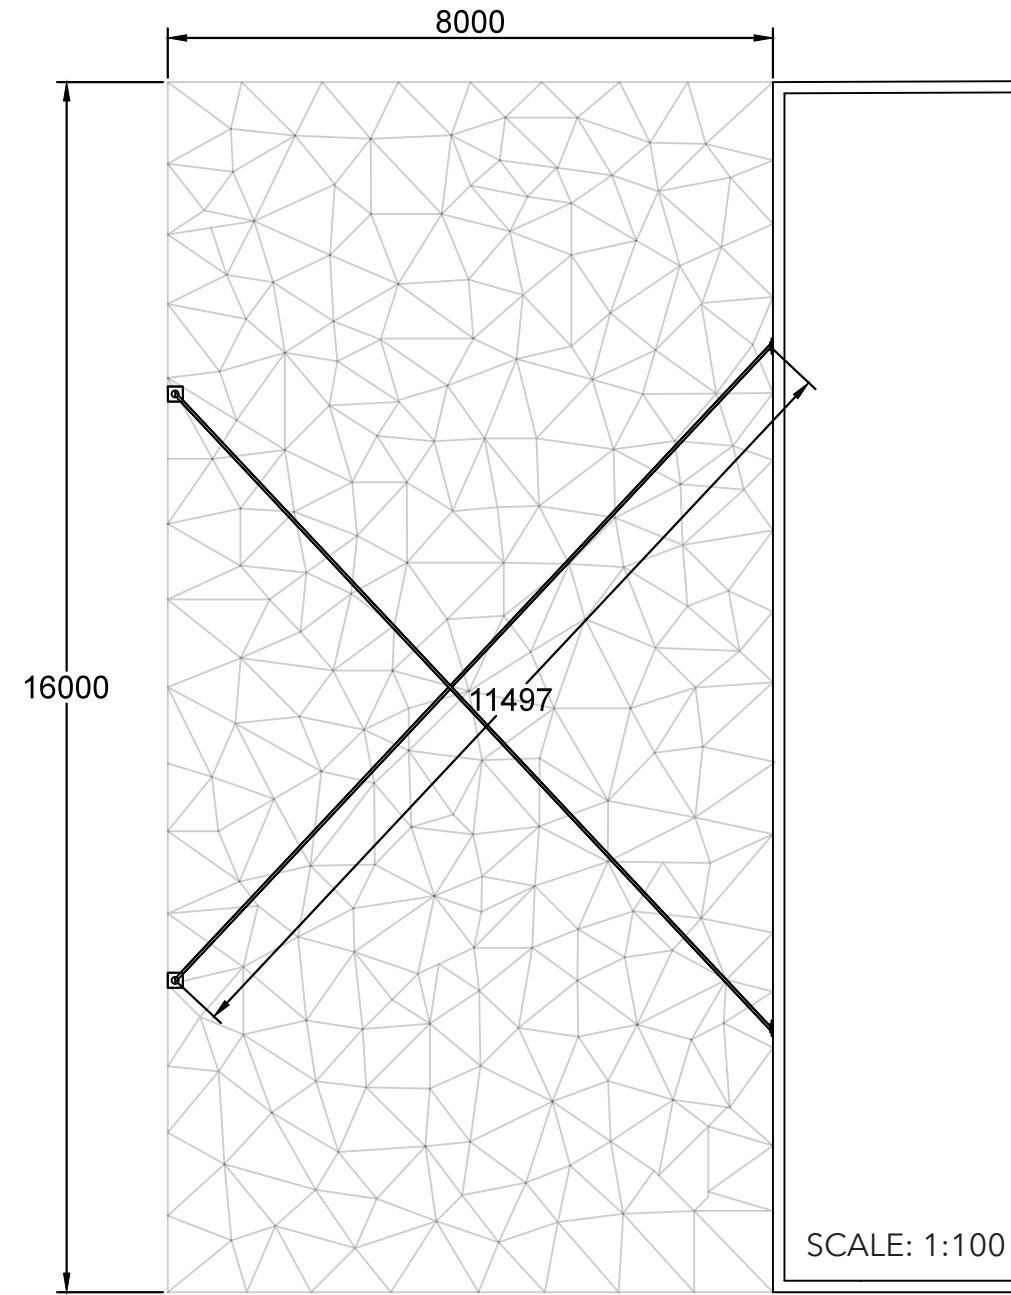

SCALE: 1:100

CANOPY HOLDING SYSTEM DETAILS

Client Name and Address
ZEYNEP INANC
UAL-LCC




Project Name and Address
Final Major Project
OP. CEMİL TOPUZLU
CADDESİ NO:108
KADIKÖY / İSTANBUL

Project FMP	Sheet 10 of 16
Date 28/04/2018	Scale 1:20



HOLDER DETAIL

SCALE: 1:20


2/10

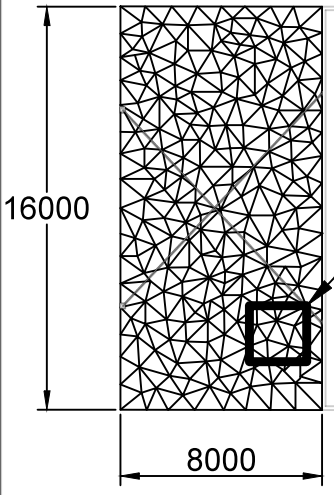


Refer to details below for construction

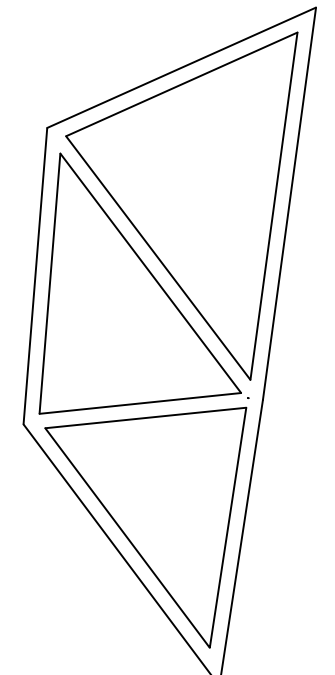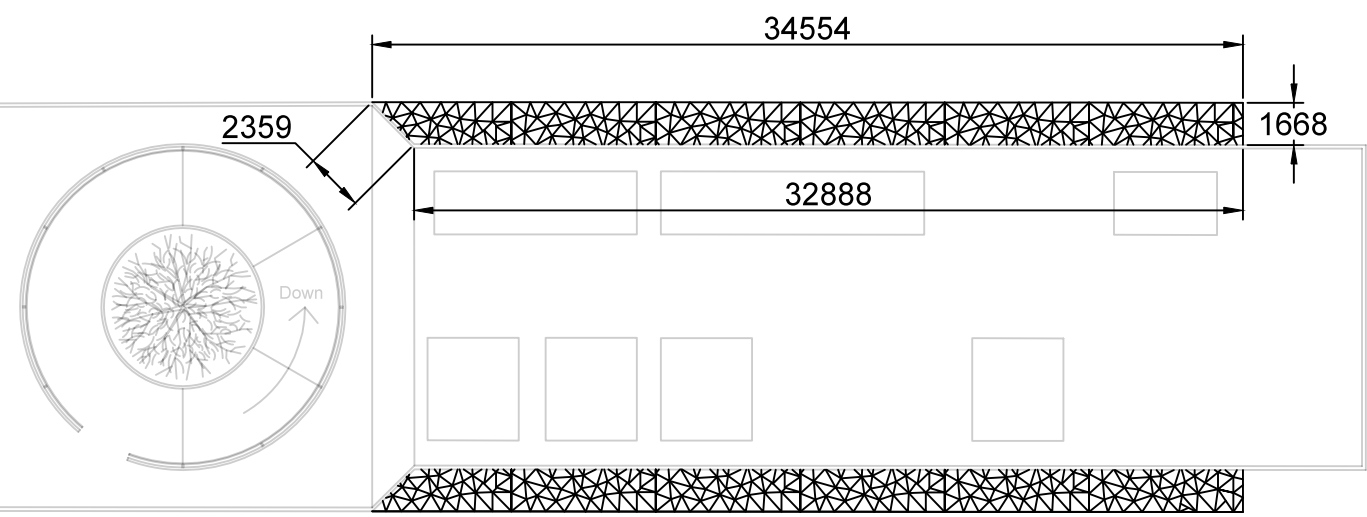

FRAMING:- PLYWOOD 30X40 MM

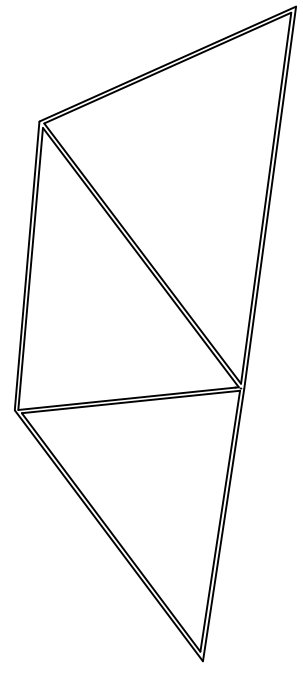

FRAMING:- PLYWOOD 30X15 MM

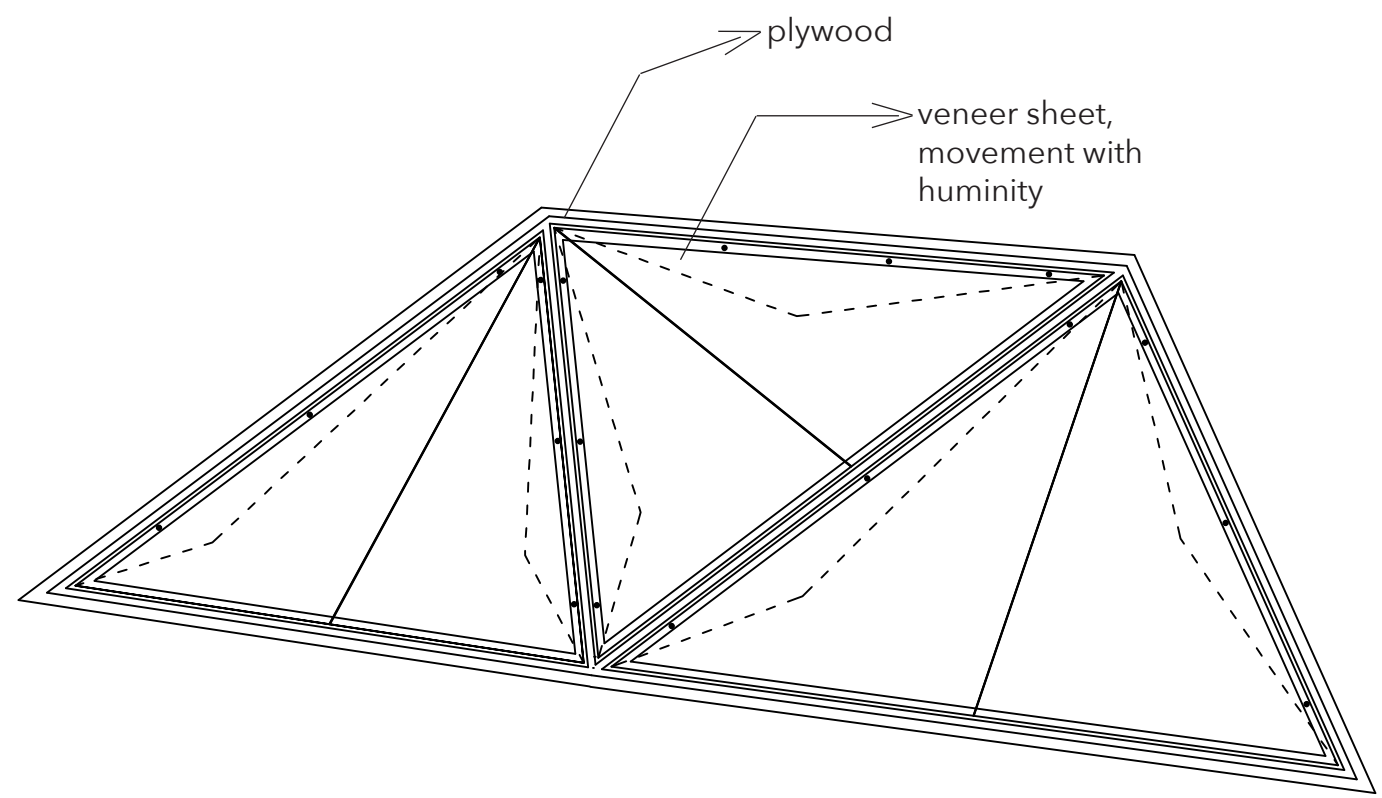

CANOPY DETAIL

SCALE: 1:2

3
11




CANOPY
CONSTRUCTION
DETAILS

Client Name and Address
ZEYNEP INANC
UAL-LCC

Project Name and Address
Final Major Project
OP. CEMİL TOPUZLU
CADDESİ NO:108
KADIKÖY / ISTANBUL

Project
FMP
Date
28/04/2018
Scale
1:2

11 of 16

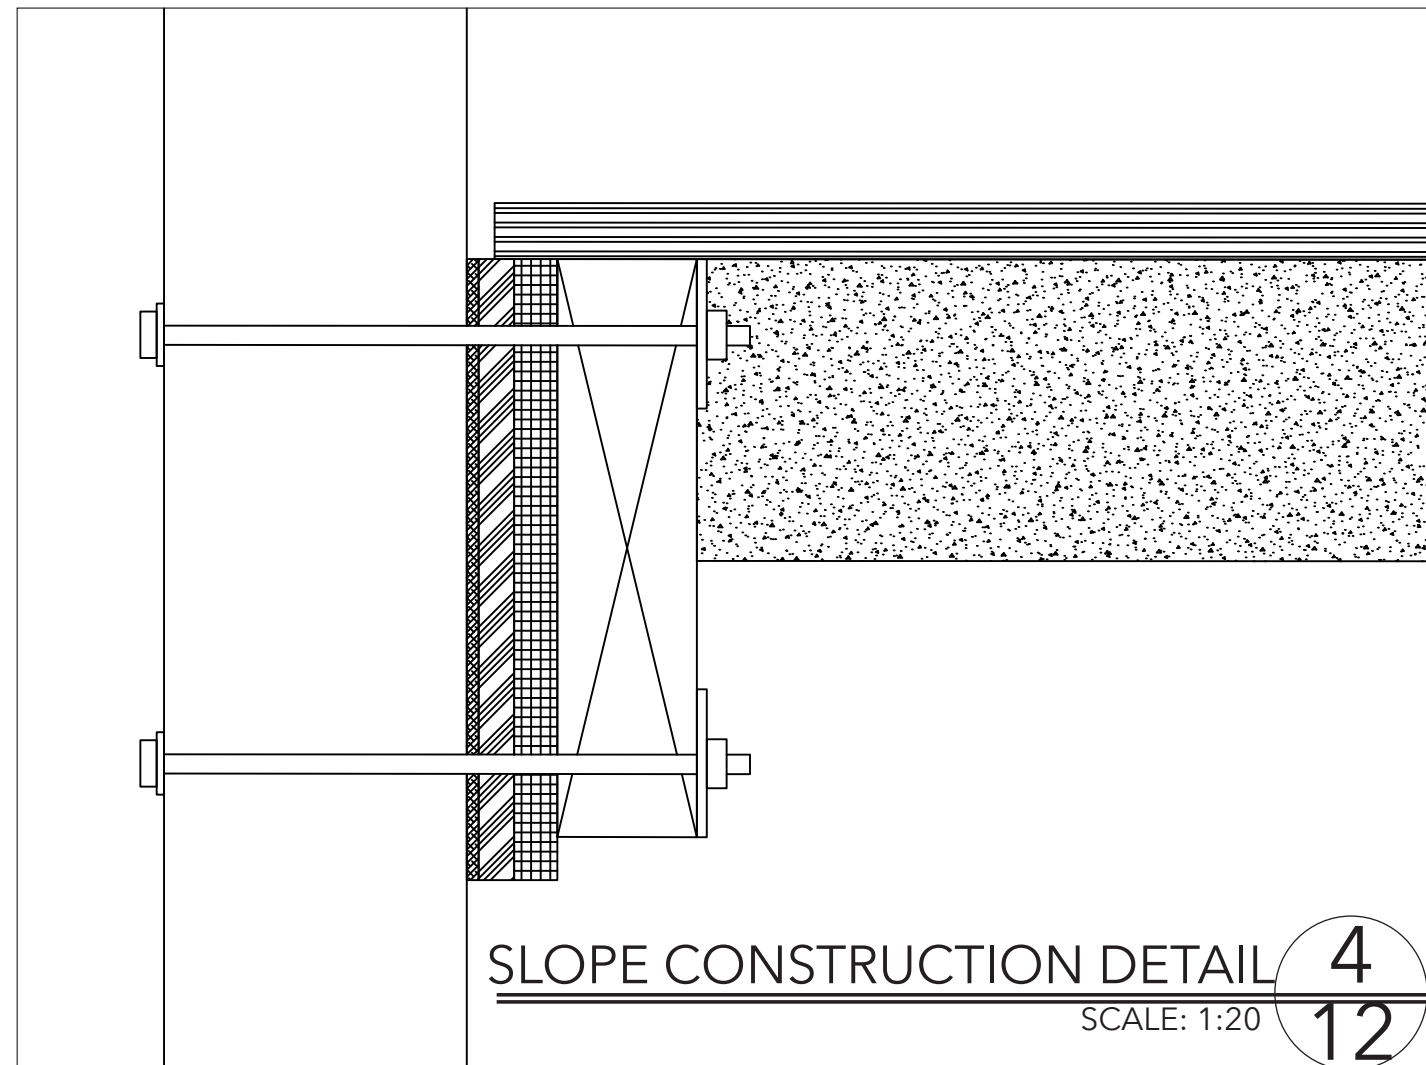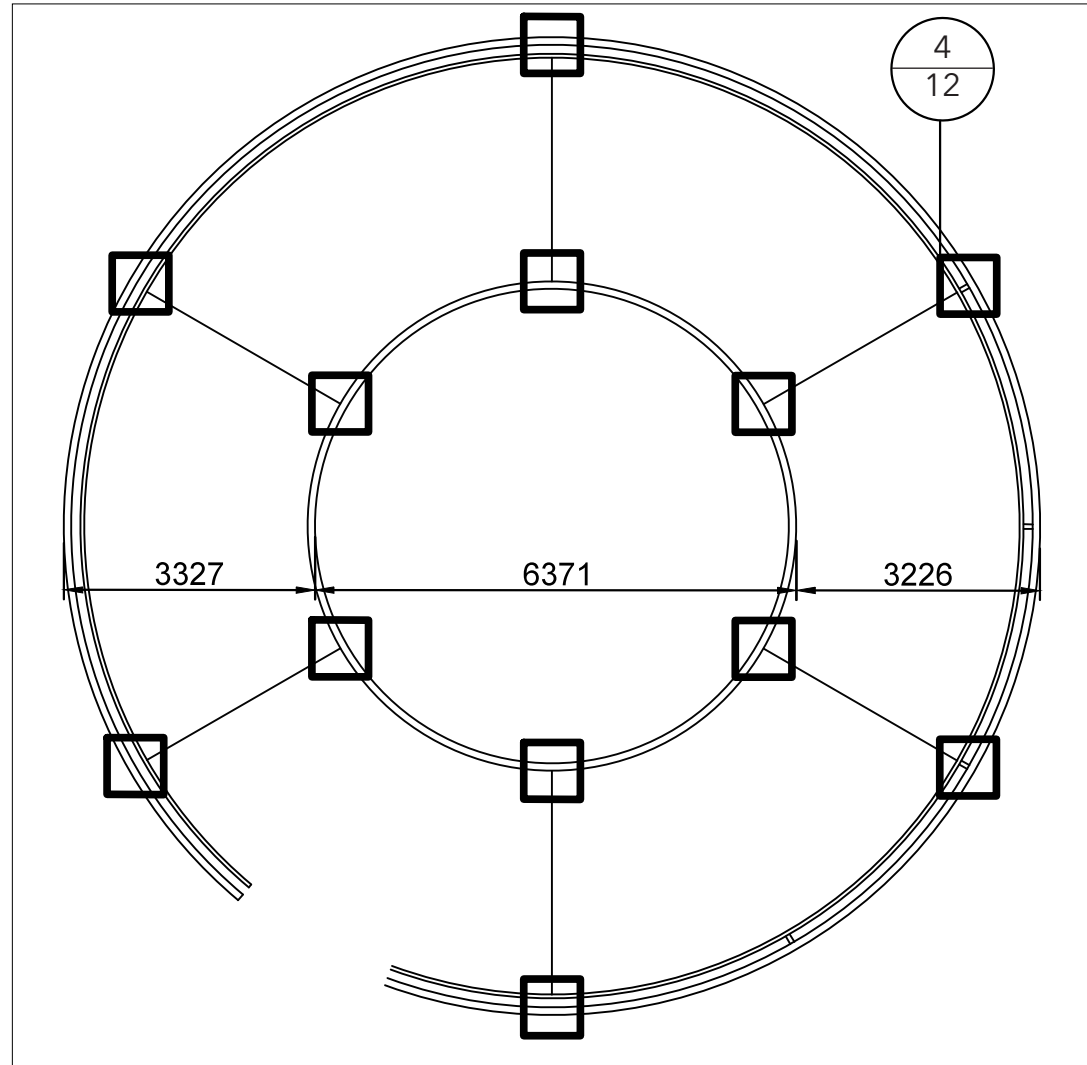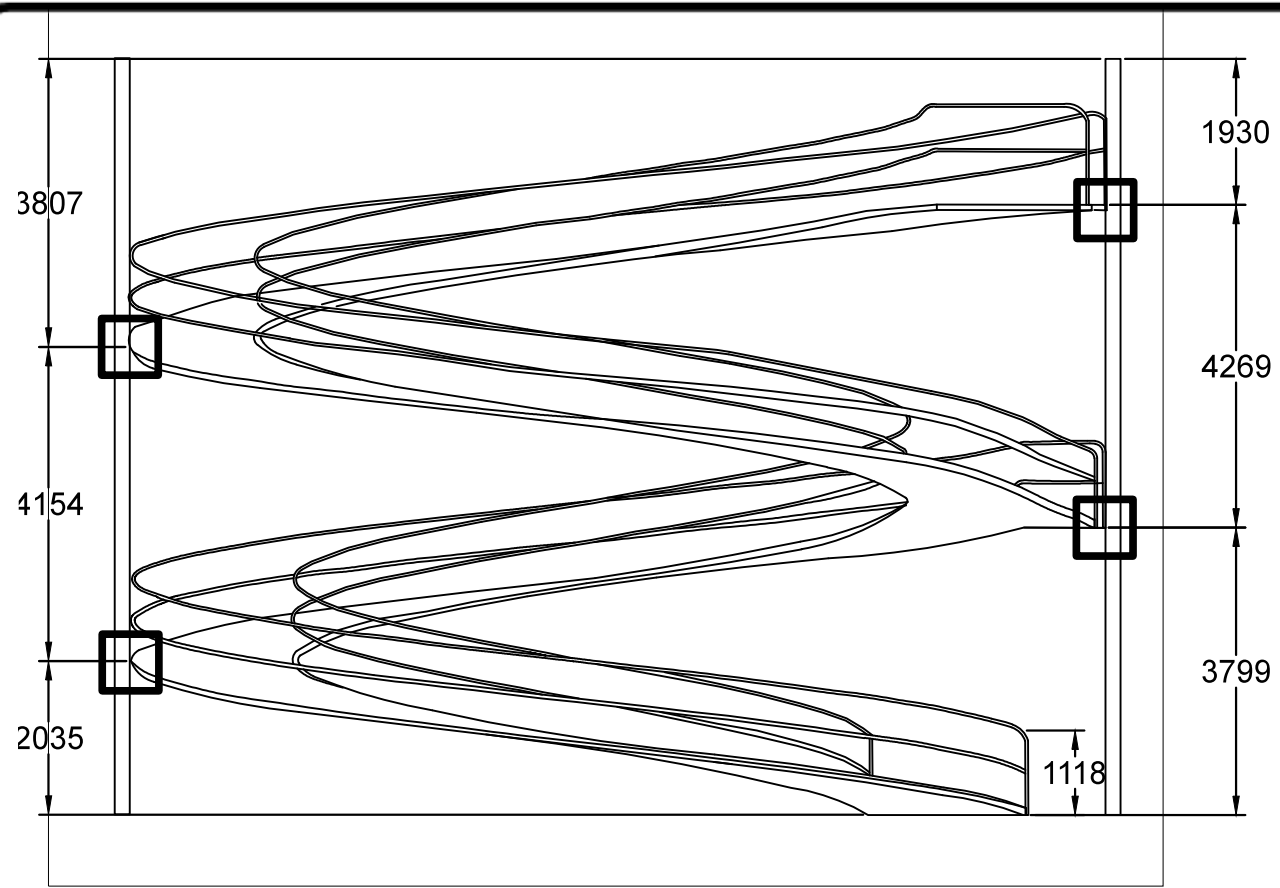


SLOPE CONSTRUCTION DETAILS

Client Name and Address
ZEYNEP INANC
UAL-LCC



Project Name and Address
Final Major Project
OP. CEMİL TOPUZLU
CAĐDESİ NO:108
KADIKÖY / İSTANBUL

Project FMP	Sheet 12 of 16
Date 28/04/2018	Scale 1:20

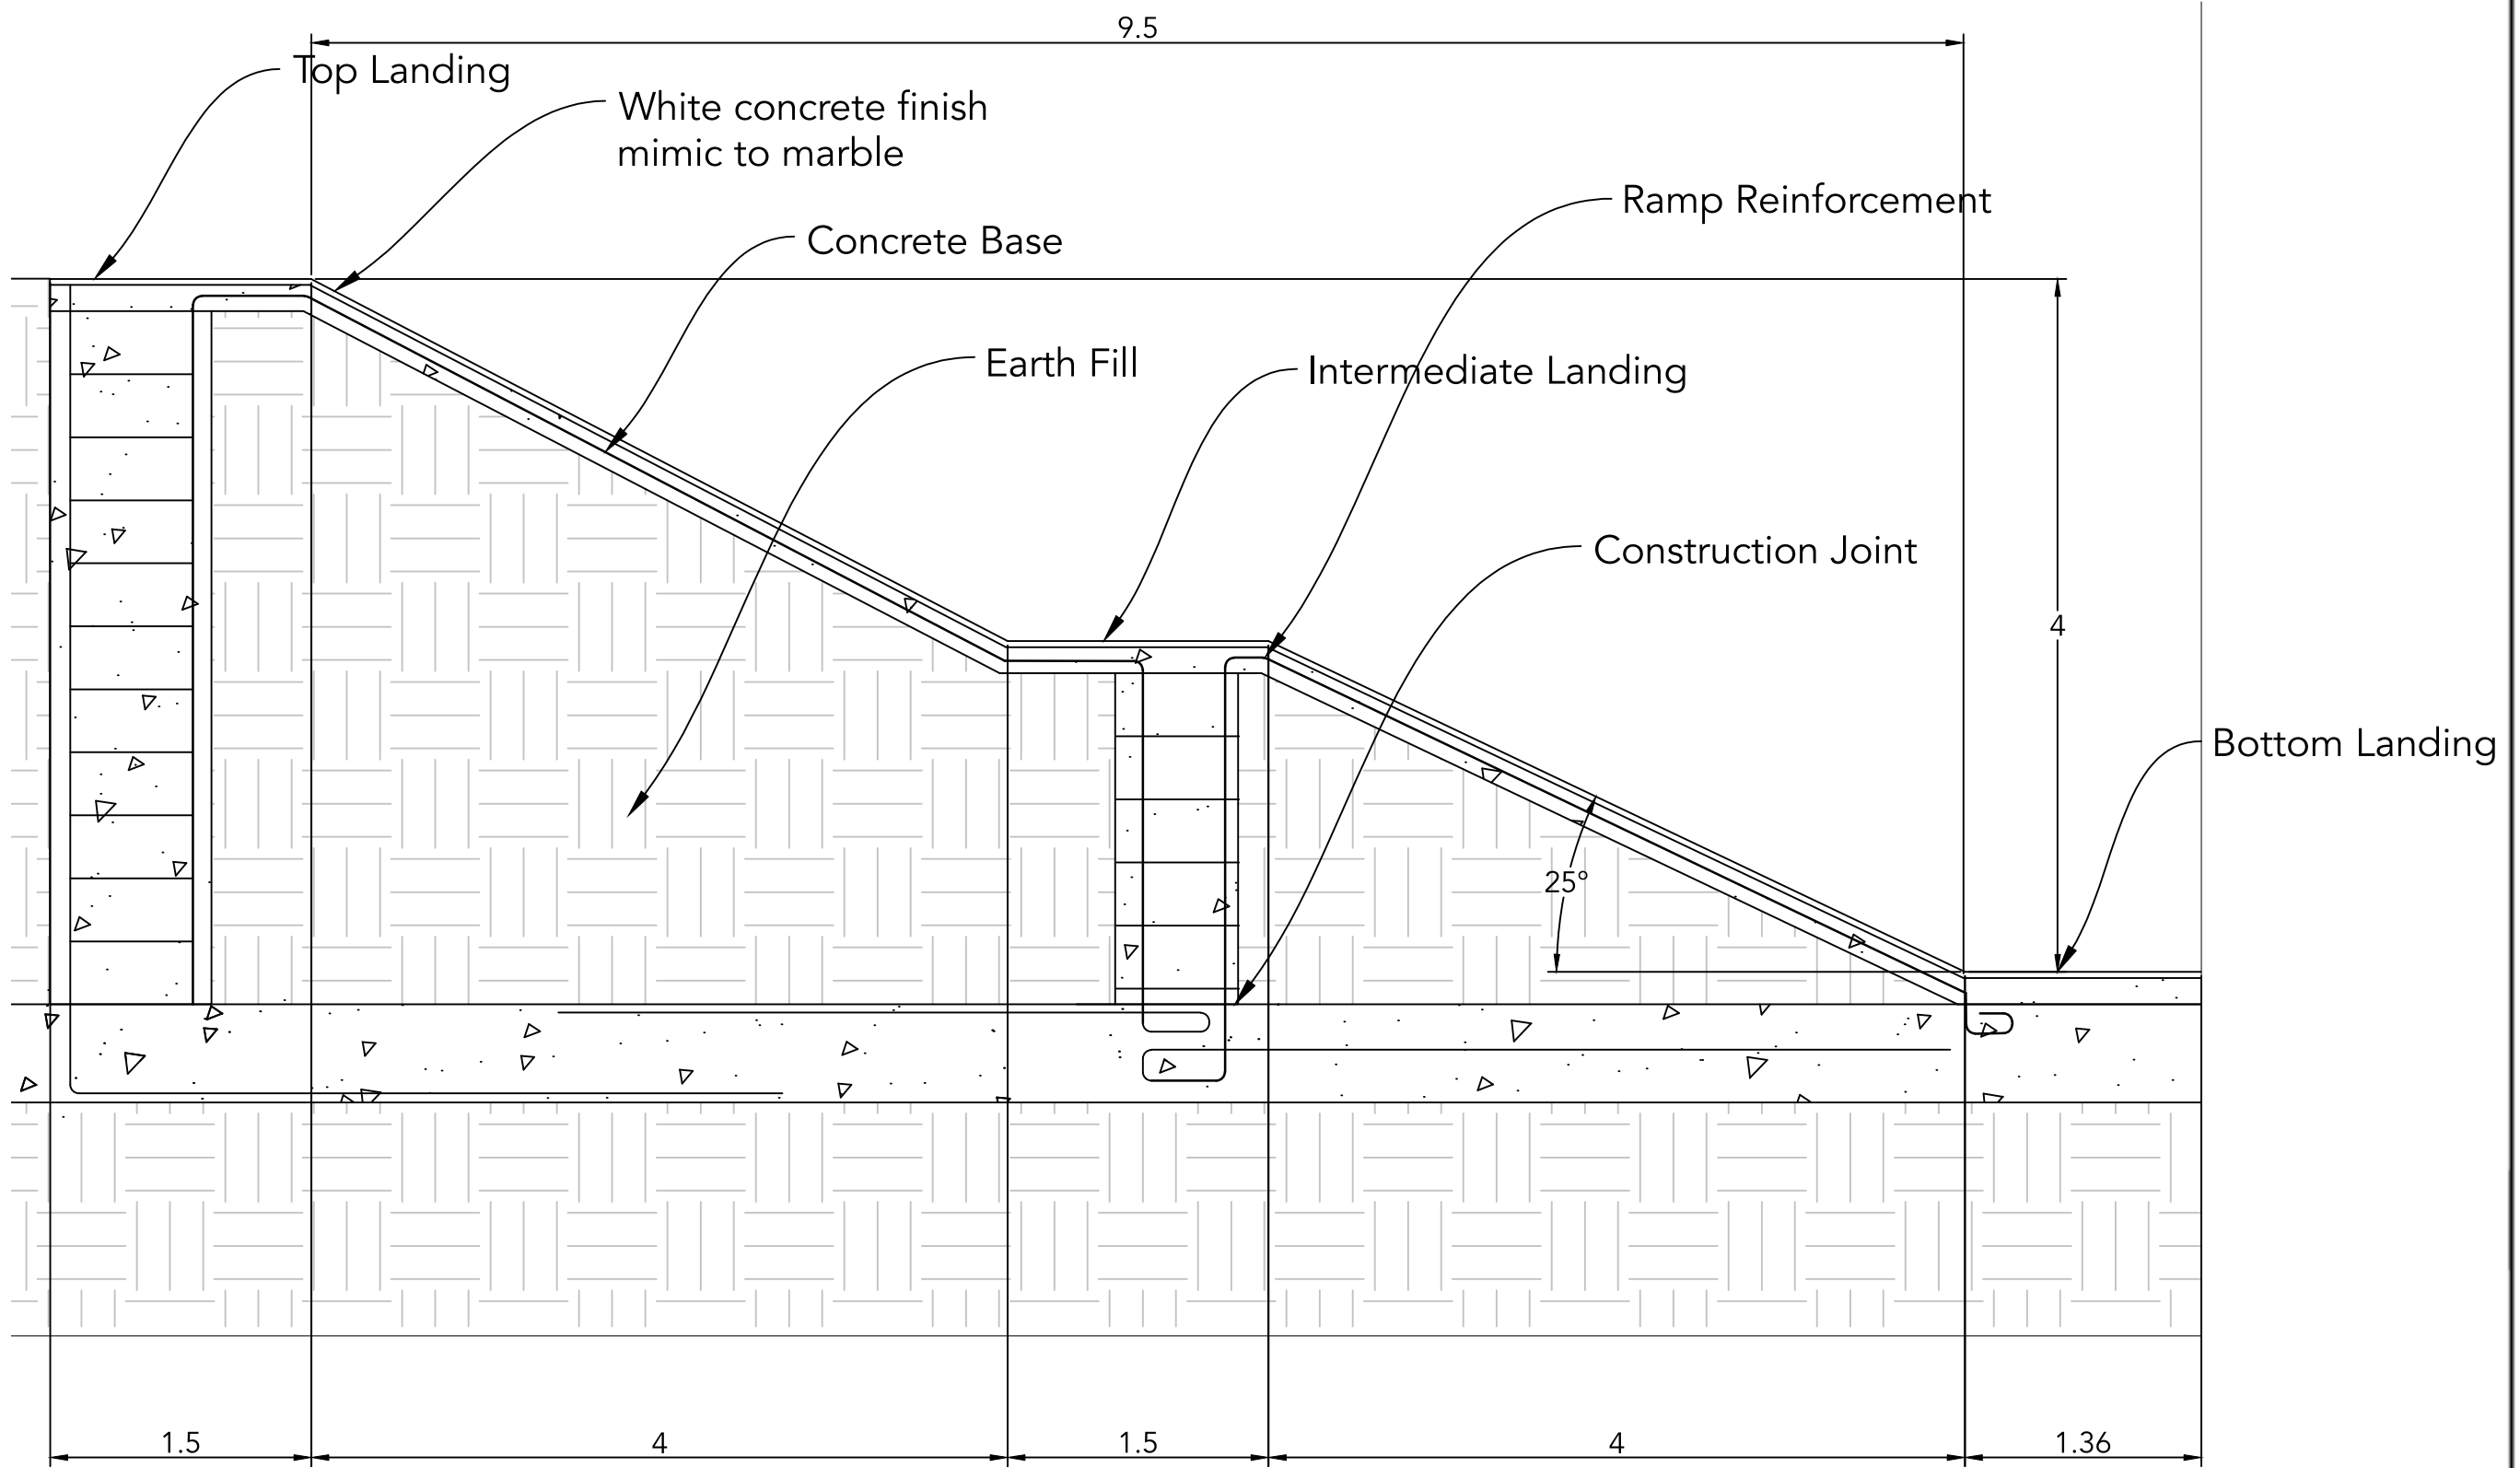

RAMP DETAIL

Yeni İsim ve Adres
ZEYNEP INANC
UAL-LCC



Proje İsim ve Adres
Final Major Project
OP. CEMİL TOPUZLU
CADESİ NO:108
KADIKÖY / İSTANBUL



Proje
FMP
Tarih
28/04/2018
Durum
13 of 16

RAMP DETAIL

SCALE: 1:40

5
13

SYMBOLS	SIZES	QUANTITY	SUPPLIER	COST	TOTAL
	D:- 47CM	22	KOÇTAŞ	50TL (8GBP)	1,100TL (184GBP)
	D:- 10 CM	285	KOÇTAŞ	21TL (3.5GBP)	6,000TL (997GBP)
	20X10 CM	56	KOÇTAŞ	36TL (6GBP)	2,016TL (336GBP)
					9,116TL 1,519(GBP)

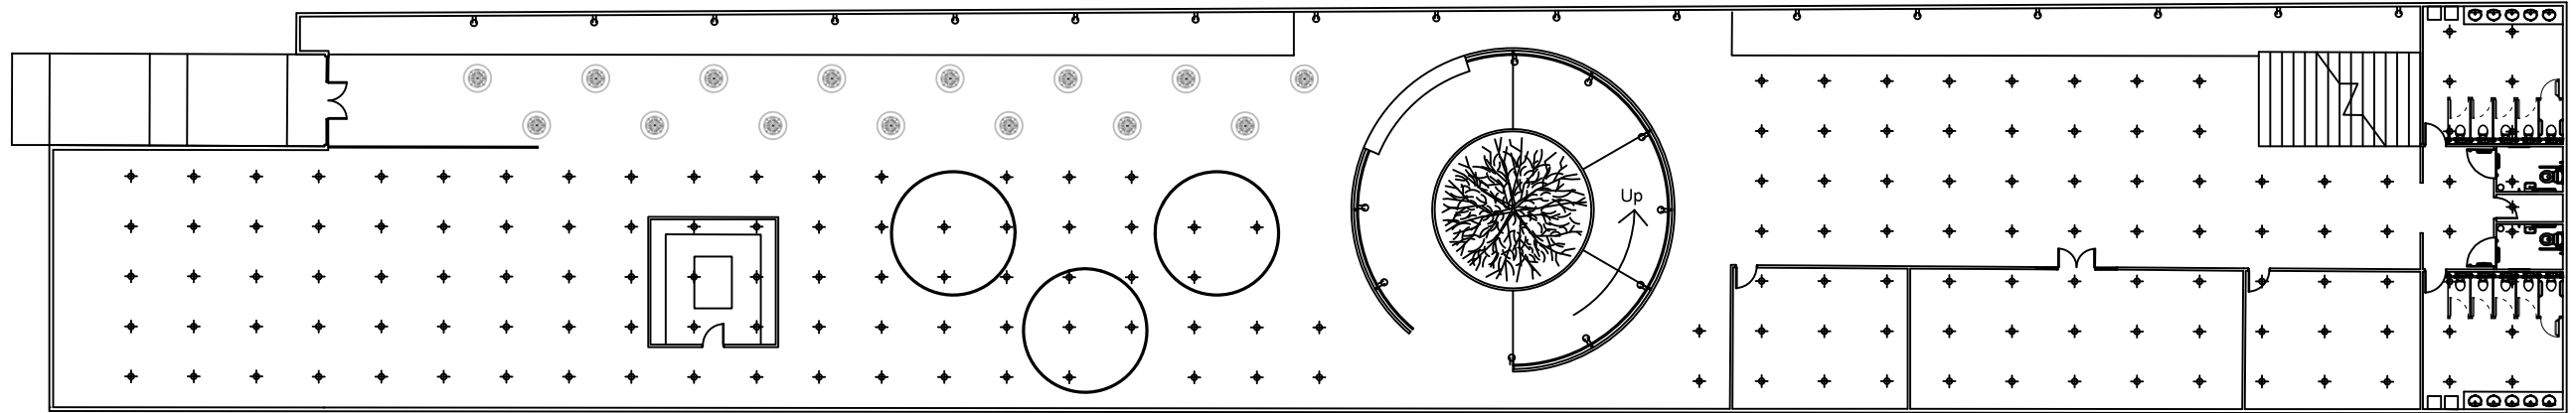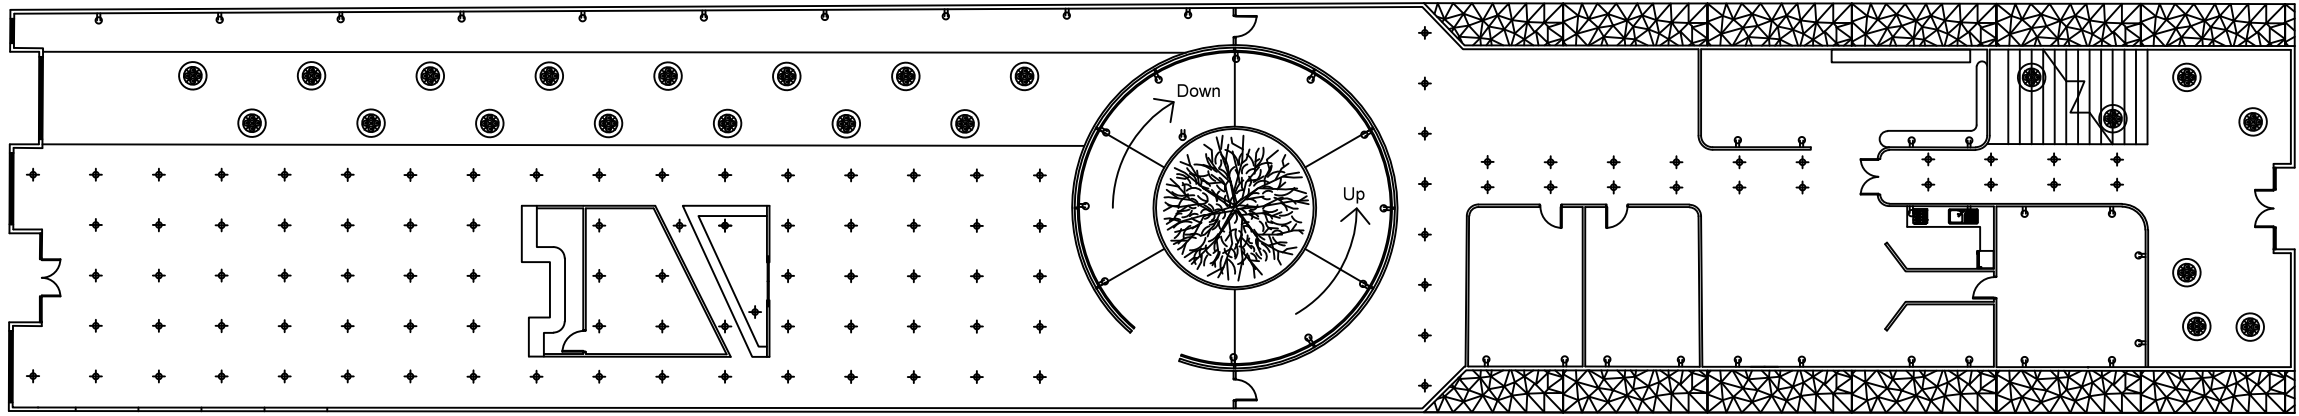

LIGHTING SCHEDULE

-  pendant lights
-  spot lights
-  wall lights

Client Name and Address
ZEYNEP INANC
UAL-LCC


Project Name and Address
Final Major Project
OP. CEMİL TOPUZLU
CADESİ NO:108
KADIKÖY / İSTANBUL

Project
FMP
Date
28/04/2018
Scale

14 of 16

LIGHTING PLAN

SCALE: 1:300

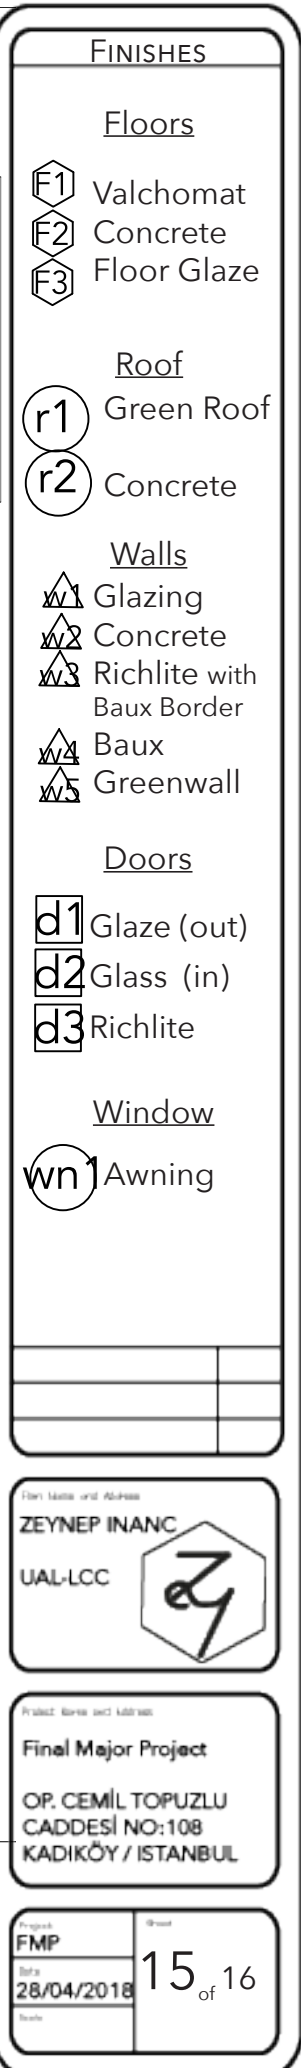

SYMB	MATERIAL	SIZE	COLOUR
F1	VALCHOMAT FIRE RETERDANT	d:- 3660x2440mm t:- 19mm	SLS- LIGHT GREY
F2	POLISHED CONCRETE	d:-1200x1200mm t:-35mm	WHITE TO MIMIC MARBLE
F3	FLOOR GLAZING	d:-6000x 6000mm t:- 42mm	TRANSPERANT
V1	TRIPLE GLAZING	d:6000x8000 t:- 42mm	TRANSPARENT
V2	POLISHED CONCRETE	d:-1200x1200mm t:-35mm	WHITE TO MIMIC MARBLE
V3	RICHLITE WITH BAUX BORDER	d1:-1000x3000mm t1:- 35mm d2:- 1160x580mm t2:- 18mm	R50 2030-Y40R
V4	BAUX	d:- 1160x580mm t:- 18mm	2030-Y40R
V5	GREENWALL	t:- 30mm + greens	AJUNA REPTENS

SYMB	MATERIAL	Size
r1	GREEN ROOF	h:-150mm
r2	CONCRETE	d:-800x800mm t:- 35mm



VALCHOMAT FIRE RETERDANT



POLISHED CONCRETE BAUX



CONCRETE

SAMPLES

FINISH SCHEDULE

Client Name and Address	
ZEYNEP INANC	
UAL-LCC	

Project Name and Address	
Final Major Project	
OP. CEMİL TOPUZLU	
CADDESİ NO:108	
KADIKÖY / ISTANBUL	

Project	Drawn
FMP	
Date	16 of 16
28/04/2018	
Scale	